

1 SITE SIGNAGE PLAN



**UNLESS OTHERWISE SPECIFIED:**  
 • ALL FLUORESCENT LAMPS WILL BE T12-CW-HO LAMPS. • ALL BALLASTS WILL BE COLD START ALL-WEATHER BALLASTS. • ALL NEON TRANSFORMERS WILL BE 30 MILLIAMPS. • 120V PRIMARY POWER TO SIGNS WILL BE BY OTHERS. • ALL DATA LINES TO ELECTRONIC SIGNAGE WILL BE BY OTHERS. • ALL PAINT COLORS WILL BE SEMI-GLOSS FINISH.  
 THIS IS AN ORIGINAL COMPUTER GENERATED COLOR PRINT. COLORS REPRESENTED ON THIS PRINT MAY NOT MATCH THE PMS CHIP, VINYL OR PAINT COLORS EXACTLY. IT IS TO BE VIEWED AS A REPRESENTATION ONLY. ALL SIZES AND SHAPES DEPICTED ARE REPRESENTATIONAL AND MAY VARY FROM FINAL PRODUCT. THEY ARE ONLY FOR THE CUSTOMERS USE IN CONNECTION WITH A PROPOSED PROJECT. ARTWORK AND PRINTED MATERIAL ARE NOT TO BE USED BY ANYONE OUTSIDE OF YOUR ORGANIZATION, NOR IS IT TO BE REPRODUCED, COPIED OR EXHIBITED IN ANY FORM

WWW.GRANTSIGNS.NET

2810 SYENE RD - MADISON, WI 53713

608.838.7794



FILE NAME: 56885-SP	DATE: 01.04.18	SCALE: NTS
FILE TYPE: <input type="checkbox"/> OUT <input type="checkbox"/> PROD <input type="checkbox"/> OTHER		
JOB NAME: TOWN BANK - RACINE		
LOCATION: 5101 E. WASHINGTON, RACINE, WI		
DRAWN BY: CS	SALESMAN: DAN PIETRZYKOWSKI	
DESIGN APPROVED BY:		
AUTHORIZED SIGNATURE: _____		
DATE: _____		



608.838.7794



SIDE VIEW



SIMULATED NIGHT VIEW

**TOWN BANK**<sup>®</sup>  
A WINTRUST COMMUNITY BANK

**JOB DESCRIPTION**

D/F LED-ILLUMINATED MONUMENT SIGN

**CABINET, CAPS, & REVEALS**  
- ALUMINUM CONSTRUCTION  
- PAINTED AS SHOWN

**"TOWN BANK", HORIZONTAL BAR, & REGISTRATION MARK**  
- 3/4" WHITE ACRYLIC PUSH-THROUGHS BACKED W/ WHITE ACRYLIC (1/2" PROTRUDING FROM FACE)

**"A WINTRUST COMMUNITY BANK"**  
- WHITE SHOULDER-ROUTED ACRYLIC FLUSH W/ ALUMINUM FACE

STONE POLE COVER & CAP BY OTHERS

INSTALL

- R1: 12.18.17 • CS • CUSTOMER CHOSE OPTION B
- R2: 12.22.17 • CS • INCREASED HEIGHT OF POLE COVER
- R3: 1.03.18 • CS • REVERTED TO MASONRY BASE & ADDED HEIGHT OPTIONS
- R4: 1.04.18 • CS • REMOVED OPTION D, ADDED OPTION E

- WHITE (PAINT)
- TBD (PAINT)
- TBD (PAINT)

FILE NAME: 56885-01a-4 DATE: 10.13.17 SCALE: 1/2" = 1'-0"

FILE TYPE:  OUT  PROD  OTHER

JOB NAME: TOWN BANK - RACINE

LOCATION: 5101 WASHINGTON AVE. RACINE, WI

DRAWN BY: CS SALESMAN: DAN PIETRZYKOWSKI

DESIGN APPROVED BY: \_\_\_\_\_

AUTHORIZED SIGNATURE \_\_\_\_\_

DATE \_\_\_\_\_

TOTAL SQ. FT. OF SIGNAGE: 108.00 ft<sup>2</sup>

UNLESS OTHERWISE SPECIFIED: ALL FLUORESCENT LAMPS WILL BE T12-CW-HO LAMPS. ALL BALLASTS WILL BE COLD START ALL-WEATHER BALLASTS. ALL NEON TRANSFORMERS WILL BE 30 MILLIAMPS. 120V PRIMARY POWER TO SIGNS WILL BE BY OTHERS. ALL DATA LINES TO ELECTRONIC SIGNAGE WILL BE BY OTHERS. ALL PAINT COLORS WILL BE SEMI-GLOSS FINISH.

THIS IS AN ORIGINAL COMPUTER GENERATED COLOR PRINT. COLORS REPRESENTED ON THIS PRINT MAY NOT MATCH THE PMS CHIP, VINYL OR PAINT COLORS EXACTLY. IT IS TO BE VIEWED AS A REPRESENTATION ONLY. ALL SIZES AND SHAPES DEPICTED ARE REPRESENTATIONAL AND MAY VARY FROM FINAL PRODUCT. THEY ARE ONLY FOR THE CUSTOMERS USE IN CONNECTION WITH A PROPOSED PROJECT. ARTWORK AND PRINTED MATERIAL ARE NOT TO BE USED BY ANYONE OUTSIDE OF YOUR ORGANIZATION, NOR IS IT TO BE REPRODUCED, COPIED OR EXHIBITED IN ANY FORM.



IF THIS PRINTS ONTO ARTWORK PAGE THE FILE HAS BEEN SIZED TO FIT PAPER AND WILL NOT BE TO SCALE - UNCHECK THE FIT TO PAGE BOX IN ADOBE TO PRINT A SCALE PRINT

IF THIS PRINTS ONTO ARTWORK PAGE THE FILE HAS BEEN SIZED TO FIT PAPER AND WILL NOT BE TO SCALE - UNCHECK THE FIT TO PAGE BOX IN ADOBE TO PRINT A SCALE PRINT

13'-0"

# TOWN BANK®

A WINTRUST COMMUNITY BANK

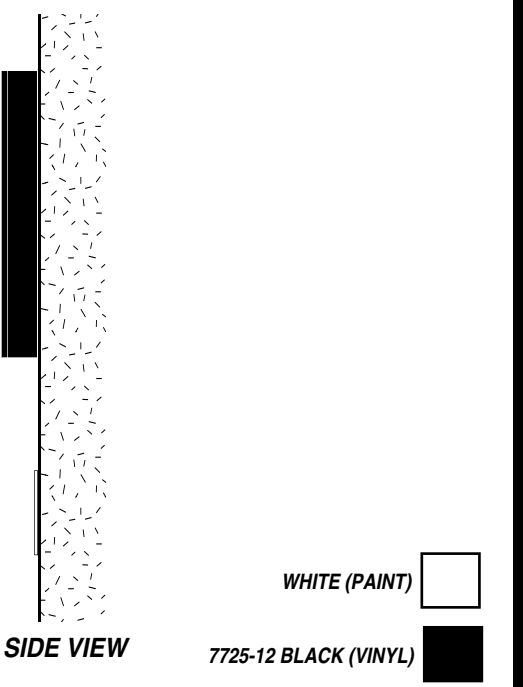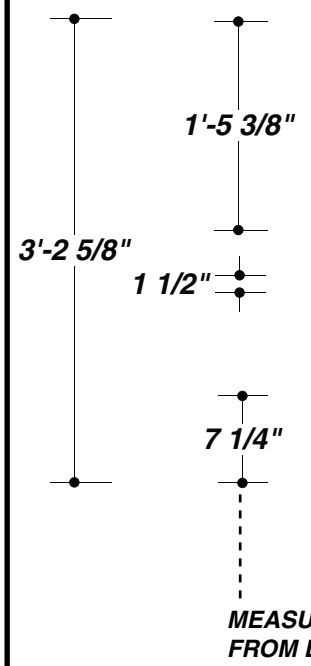

SIMULATED NIGHT VIEW

**JOB DESCRIPTION**

**LED-ILLUMINATED INDIVIDUALLY-MOUNTED CHANNEL LETTERS & ALUMINUM LETTERS**

- "TOWN BANK", REGISTERED MARK, & HORIZONTAL RULE**
- CHANNEL LETTERS
  - WHITE ACRYLIC FACES
  - REGISTERED MARK TO HAVE BLACK VINYL APPLIED
  - BLACK TRIM CAPS & RETURNS
  - 3" RETURNS
  - MOUNTED FLUSH TO BUILDING AS SHOWN

- "A WINTRUST COMMUNITY BANK"**
- FLAT CUT ALUMINUM
  - 1/4" THICK
  - PAINTED WHITE
  - MOUNTED FLUSH TO BUILDING

**INSTALL**

- R1: 12.12.17 • CS • INCORPORATED CUSTOMER-PROVIDED ART, REDUCED SIZE OF CHANNEL LETTERS
- R2: 12.14.17 • CS • REMOVED EAST & SOUTH ELEVATION RENDERINGS & INCREASED CHANNEL LETTER SIZE

FILE NAME: 56885-02-2 DATE: 10.13.17 SCALE: 3/4" = 1'-0"

FILE TYPE:  OUT  PROD  OTHER

JOB NAME: TOWN BANK - RACINE

LOCATION: 5101 WASHINGTON AVE. RACINE, WI

DRAWN BY: CS SALESMAN: DAN PIETRZYKOWSKI

DESIGN APPROVED BY: \_\_\_\_\_

AUTHORIZED SIGNATURE: \_\_\_\_\_

DATE: \_\_\_\_\_

**TOTAL SQ. FT. OF EACH SIGN: 41.84 ft<sup>2</sup>**

UNLESS OTHERWISE SPECIFIED: ALL FLUORESCENT LAMPS WILL BE T12-CW-HO LAMPS. ALL BALLASTS WILL BE COLD START ALL-WEATHER BALLASTS. ALL NEON TRANSFORMERS WILL BE 30 MILLIAMPS. 120V PRIMARY POWER TO SIGNS WILL BE BY OTHERS. ALL DATA LINES TO ELECTRONIC SIGNAGE WILL BE BY OTHERS. ALL PAINT COLORS WILL BE SEMI-GLOSS FINISH. THIS IS AN ORIGINAL COMPUTER GENERATED COLOR PRINT. COLORS REPRESENTED ON THIS PRINT MAY NOT MATCH THE PMS CHIP, VINYL OR PAINT COLORS EXACTLY. IT IS TO BE VIEWED AS A REPRESENTATION ONLY. ALL SIZES AND SHAPES DEPICTED ARE REPRESENTATIONAL AND MAY VARY FROM FINAL PRODUCT. THEY ARE ONLY FOR THE CUSTOMERS USE IN CONNECTION WITH A PROPOSED PROJECT. ARTWORK AND PRINTED MATERIAL ARE NOT TO BE USED BY ANYONE OUTSIDE OF YOUR ORGANIZATION, NOR IS IT TO BE REPRODUCED, COPIED OR EXHIBITED IN ANY FORM



608.838.7794



WEST ELEVATION

**WEST ELEVATION**  
CONCEPTUAL RENDERING (\*MAY NOT BE TO EXACT SCALE)



NORTH ELEVATION

**NORTH ELEVATION**  
CONCEPTUAL RENDERING (\*MAY NOT BE TO EXACT SCALE)

UNLESS OTHERWISE SPECIFIED: ALL FLUORESCENT LAMPS WILL BE T12-CW-HO LAMPS. ALL BALLASTS WILL BE COLD START ALL-WEATHER BALLASTS. ALL NEON TRANSFORMERS WILL BE 30 MILLIAMPS. 120V PRIMARY POWER TO SIGNS WILL BE BY OTHERS. ALL DATA LINES TO ELECTRONIC SIGNAGE WILL BE BY OTHERS. ALL PAINT COLORS WILL BE SEMI-GLOSS FINISH.

THIS IS AN ORIGINAL COMPUTER GENERATED COLOR PRINT. COLORS REPRESENTED ON THIS PRINT MAY NOT MATCH THE PMS CHIP, VINYL OR PAINT COLORS EXACTLY. IT IS TO BE VIEWED AS A REPRESENTATION ONLY. ALL SIZES AND SHAPES DEPICTED ARE REPRESENTATIONAL AND MAY VARY FROM FINAL PRODUCT. THEY ARE ONLY FOR THE CUSTOMERS USE IN CONNECTION WITH A PROPOSED PROJECT. ARTWORK AND PRINTED MATERIAL ARE NOT TO BE USED BY ANYONE OUTSIDE OF YOUR ORGANIZATION, NOR IS IT TO BE REPRODUCED, COPIED OR EXHIBITED IN ANY FORM.

FILE NAME: 56885-02-2 DATE: 10.13.17 SCALE: 3/4" = 1'-0"  
FILE TYPE:  OUT  PROD  OTHER  
JOB NAME: TOWN BANK - RACINE  
LOCATION: 5101 WASHINGTON AVE. RACINE, WI  
DRAWN BY: CS SALESMAN: DAN PIETRZYKOWSKI

DESIGN APPROVED BY: \_\_\_\_\_  
AUTHORIZED SIGNATURE: \_\_\_\_\_  
DATE: \_\_\_\_\_





WHITE (PAINT)

7725-12 BLACK (VINYL)

**JOB DESCRIPTION**

**NON-ILLUMINATED INDIVIDUALLY-MOUNTED DIMENSIONAL LETTERS**

**"TOWN BANK", REGISTERED MARK, AND HORIZONTAL BAR**

- METAL LETTERS
- PAINTED WHITE
- REGISTERED MARK TO HAVE BLACK VINYL APPLIED
- 1-1/2" THICK
- MOUNTED FLUSH TO BUILDING

**"A WINTRUST COMMUNITY BANK"**

- FLAT CUT ALUMINUM
- 1/4" THICK
- PAINTED WHITE
- MOUNTED FLUSH TO BUILDING

**INSTALL**

FILE NAME: 56885-02a-0 DATE: 10.13.17 SCALE: 3/4" = 1'-0"

FILE TYPE:  OUT  PROD  OTHER

JOB NAME: TOWN BANK - RACINE

LOCATION: 5101 WASHINGTON AVE. RACINE, WI

DRAWN BY: CS SALESMAN: DAN PIETRZYKOWSKI

DESIGN APPROVED BY: \_\_\_\_\_

AUTHORIZED SIGNATURE: \_\_\_\_\_

DATE: \_\_\_\_\_

**TOTAL SQ. FT. OF EACH SIGN: 36.25 ft<sup>2</sup>**


UNLESS OTHERWISE SPECIFIED: ALL FLUORESCENT LAMPS WILL BE T12-CW-HO LAMPS. ALL BALLASTS WILL BE COLD START ALL-WEATHER BALLASTS. ALL NEON TRANSFORMERS WILL BE 30 MILLIAMPS. 120V PRIMARY POWER TO SIGNS WILL BE BY OTHERS. ALL DATA LINES TO ELECTRONIC SIGNAGE WILL BE BY OTHERS. ALL PAINT COLORS WILL BE SEMI-GLOSS FINISH. THIS IS AN ORIGINAL COMPUTER GENERATED COLOR PRINT. COLORS REPRESENTED ON THIS PRINT MAY NOT MATCH THE PMS CHIP, VINYL OR PAINT COLORS EXACTLY. IT IS TO BE VIEWED AS A REPRESENTATION ONLY. ALL SIZES AND SHAPES DEPICTED ARE REPRESENTATIONAL AND MAY VARY FROM FINAL PRODUCT. THEY ARE ONLY FOR THE CUSTOMERS USE IN CONNECTION WITH A PROPOSED PROJECT. ARTWORK AND PRINTED MATERIAL ARE NOT TO BE USED BY ANYONE OUTSIDE OF YOUR ORGANIZATION, NOR IS IT TO BE REPRODUCED, COPIED OR EXHIBITED IN ANY FORM



608.838.7794

IF THIS PRINTS ONTO ARTWORK PAGE THE FILE HAS BEEN SIZED TO FIT PAPER AND WILL NOT BE TO SCALE - UNCHECK THE FIT TO PAGE BOX IN ADOBE TO PRINT A SCALE PRINT

IF THIS PRINTS ONTO ARTWORK PAGE THE FILE HAS BEEN SIZED TO FIT PAPER AND WILL NOT BE TO SCALE - UNCHECK THE FIT TO PAGE BOX IN ADOBE TO PRINT A SCALE PRINT

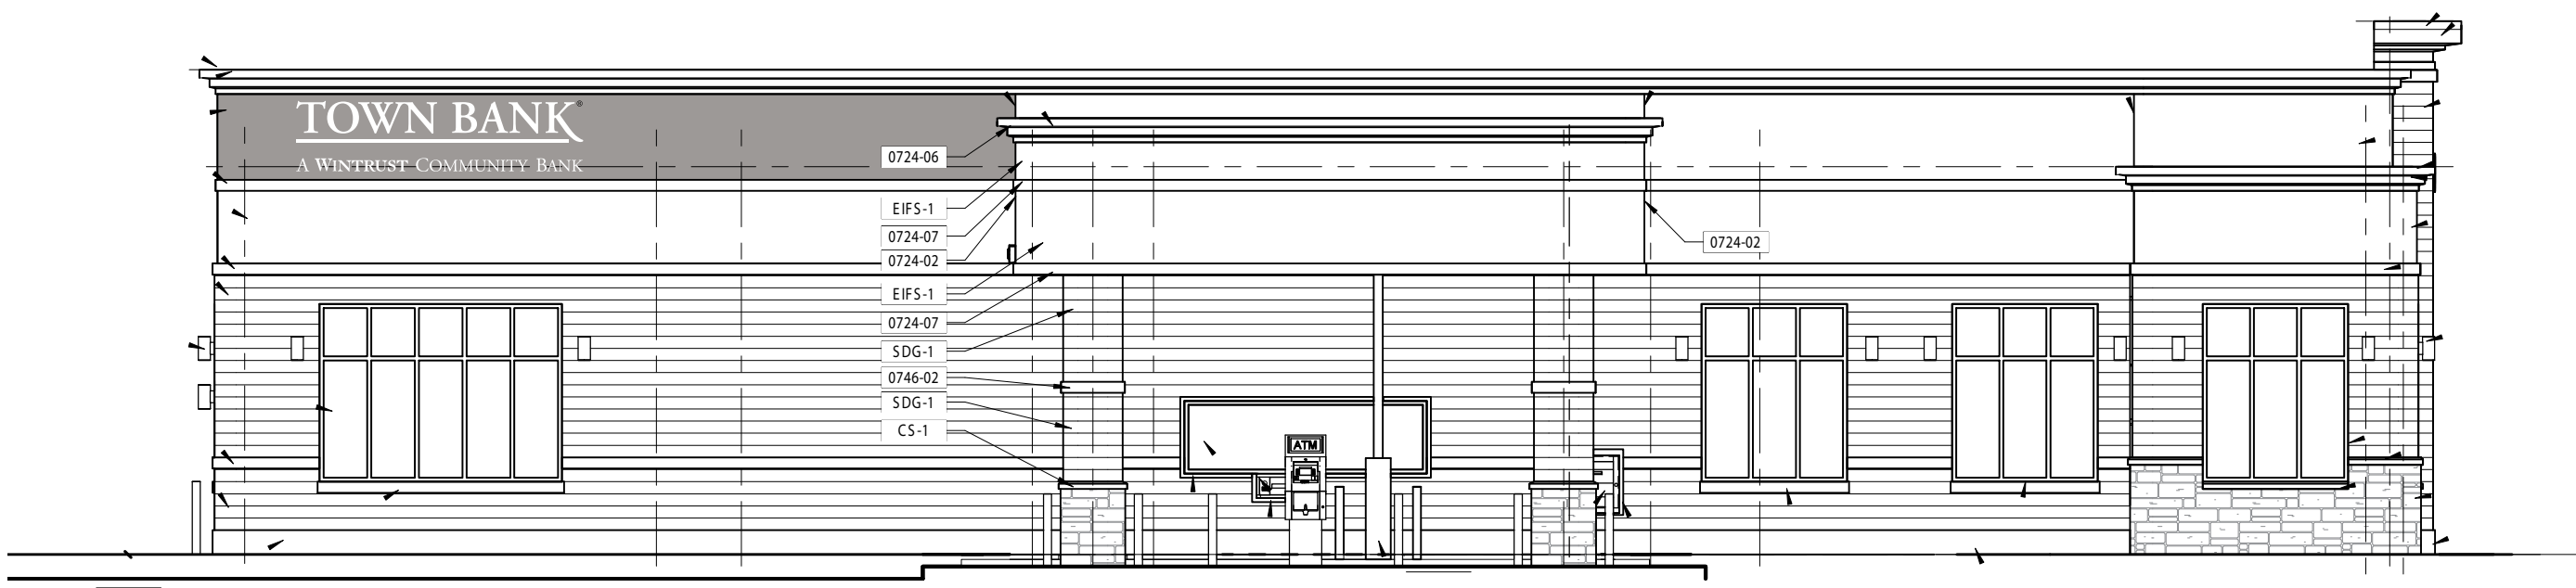

EAST ELEVATION

**EAST ELEVATION**  
 CONCEPTUAL RENDERING (\*MAY NOT BE TO EXACT SCALE)

**GRANT SIGNS**  
 DP INDUSTRIES, LLC

608.  
838.7794

FILE NAME: 56885-02a-0 DATE: 10.13.17 SCALE: 3/4" = 1'-0"  
 FILE TYPE:  OUT  PROD  OTHER \_\_\_\_\_  
 JOB NAME: TOWN BANK - RACINE  
 LOCATION: 5101 WASHINGTON AVE. RACINE, WI  
 DRAWN BY: CS SALESMAN: DAN PIETRZYKOWSKI

---

DESIGN APPROVED BY: \_\_\_\_\_  
 AUTHORIZED SIGNATURE: \_\_\_\_\_  
 DATE: \_\_\_\_\_

UNLESS OTHERWISE SPECIFIED:  
 • ALL FLUORESCENT LAMPS WILL BE T12-CW-HO LAMPS. • ALL BALLASTS WILL BE COLD START ALL-WEATHER BALLASTS. • ALL NEON TRANSFORMERS WILL BE 30 MILLIAMPS. • 120V PRIMARY POWER TO SIGNS WILL BE BY OTHERS. • ALL DATA LINES TO ELECTRONIC SIGNAGE WILL BE BY OTHERS. • ALL PAINT COLORS WILL BE SEMI-GLOSS FINISH.



THIS IS AN ORIGINAL COMPUTER GENERATED COLOR PRINT. COLORS REPRESENTED ON THIS PRINT MAY NOT MATCH THE PMS CHIP, VINYL OR PAINT COLORS EXACTLY. IT IS TO BE VIEWED AS A REPRESENTATION ONLY. ALL SIZES AND SHAPES DEPICTED ARE REPRESENTATIONAL AND MAY VARY FROM FINAL PRODUCT. THEY ARE ONLY FOR THE CUSTOMERS USE IN CONNECTION WITH A PROPOSED PROJECT. ARTWORK AND PRINTED MATERIAL ARE NOT TO BE USED BY ANYONE OUTSIDE OF YOUR ORGANIZATION, NOR IS IT TO BE REPRODUCED, COPIED OR EXHIBITED IN ANY FORM

WWW.GRANTSIGNS.NET

2810 SYENE RD - MADISON, WI 53713

608.838.7794



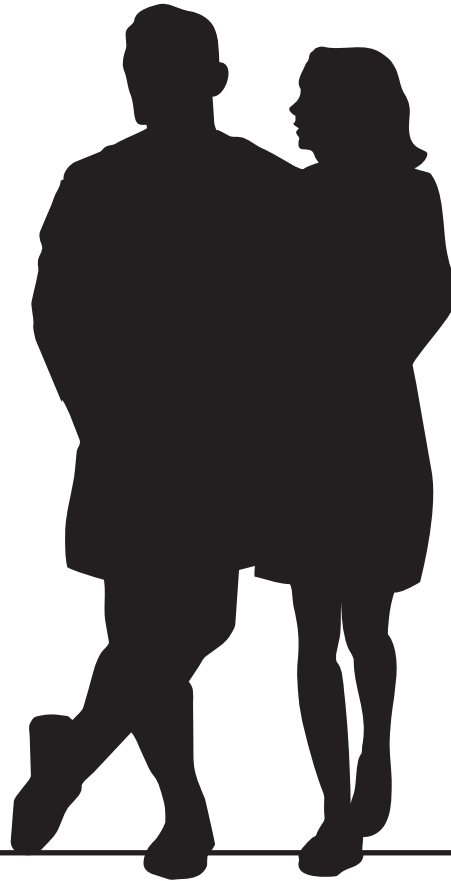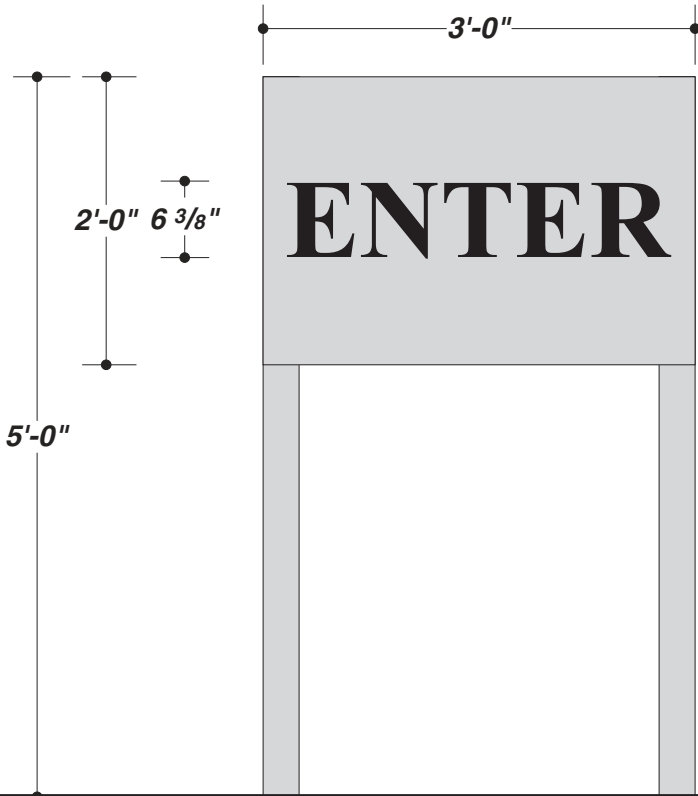

**JOB DESCRIPTION**

*D/F NON-ILLUMINATED GROUND SIGN*

*ALUMINUM CONSTRUCTION*

*VINYL GRAPHICS APPLIED AS SHOWN*

R1: 01.04.18 • CS • UPDATED DESIGN

FILE NAME: 56885-03-1 DATE: 10.13.17 SCALE: 3/4"=1'-0"

FILE TYPE:  OUT  PROD  OTHER \_\_\_\_\_

JOB NAME: TOWN BANK - RACINE

LOCATION: 5101 WASHINGTON AVE, RACINE, WI

DRAWN BY: CS SALESMAN: DAN PIETRZYKOWSKI

DESIGN APPROVED BY:  
AUTHORIZED SIGNATURE \_\_\_\_\_

DATE \_\_\_\_\_

7725-12 BLACK (VINYL) 

**TOTAL SQ. FT. OF SIGNAGE: 00.00 ft<sup>2</sup>**

ALL SIZES, SHAPES AND COLORS DEPICTED ARE REPRESENTATIONAL AND MAY VARY FROM FINAL PRODUCT.

