



Application for Design Review for Industrial Parks

Applicant Name: Jacquet Midwest
Address: 1908 DeKoven Ave City: Racine
State: WI Zip: 53403
Telephone: (262) 898-1381 Cell Phone: (262) 909-4263
Email: d.chatterton@myjacquet.com

Agent Name: Mayer Helminiak Architectural Design
Address: 311 E Chicago St. Ste 310 City: Milwaukee
State: WI Zip: 53202
Telephone: 2622369601 Cell Phone: 4143051183
Email: cmayer@mayer-helminiak.com

Property Address (Es): 1908 DeKoven Ave
Current Zoning: I-2
Current/Most Recent Property Use: Manufacturing
Proposed Use: Manufacturing



If the required supplemental materials, which constitute a completed application, are not submitted, the application will not be processed.

Required Submittal Format

1. An electronic submission via email/USB drive/CD/Download link; and
2. One (1) paper copy, no larger than 11" x 17" size.

Required Submittal Item	Applicant Submitted	City Received
1. Industrial Park Review Application		
2. Written description of project, including: a. Hours of operation b. Anticipated delivery schedule c. Maintenance plan d. General use of the building and lot	☒	
3. Site Plan (drawn to scale), including: a. Fully dimensioned property boundary b. All buildings (existing and proposed) c. Setbacks from property lines d. Identification as to whether all elements are "Existing" or "Proposed" e. Dimensioned parking spaces and drive aisle layout f. Trash enclosure location and materials g. Loading spaces h. Location of signage, with setbacks	☒	
4. Landscape Plan a. Bufferyards b. Parking Areas c. Screening and fencing locations d. Plant lists including the following: Latin and Common Names, Number of each planting material, and Size at planting.	☒	
5. Lighting Plan a. Location of light fixtures b. A cut sheet of light fixtures with indication of cut-offs or shielding c. Illumination diagram indicating intensity of lighting on the property.	☒	
6. Signage Plan a. dimensioned color elevations of signage b. A diagram showing the location of the proposed signage	☒	
7. Building/site elevations a. Building elevations showing all four sides of the buildings in color b. Elevation of trash enclosure area	☒	
8. Building Material Samples (if making exterior changes)	☒	



Acknowledgement and authorization signatures

Design Review is not like a building permit; applying does not mean it will be approved.



The approval may contain conditions related to the improvement of the site which must be met prior to the issuance of a building occupancy permit. Conditions related to the operational aspect(s) of the business must be complied with at all times. That, in the event site improvement work required by ordinance cannot be completed prior to desired occupancy, a financial assurance, at 100% of the improvement estimate, guaranteeing completion of the required improvements must be placed on file with the City of Racine. Estimates and Assurance documents are subject to the review and final approval by the City. Improvements may include but are not limited to landscaping, fencing, lighting, pavement surfacing and sealing, dumpster enclosures, and exterior building improvements;

The signature(s) hereby certify that the statements made by myself and constituting part of this application are true and correct. I am fully aware that any misrepresentation of any information on this application may be grounds for denial of this application.

Owner Signature (acknowledgement and authorization): Daniel Chatterton Date: 5-27-21

Applicant Signature (acknowledgement): Daniel Chatterton Date: 5-27-21



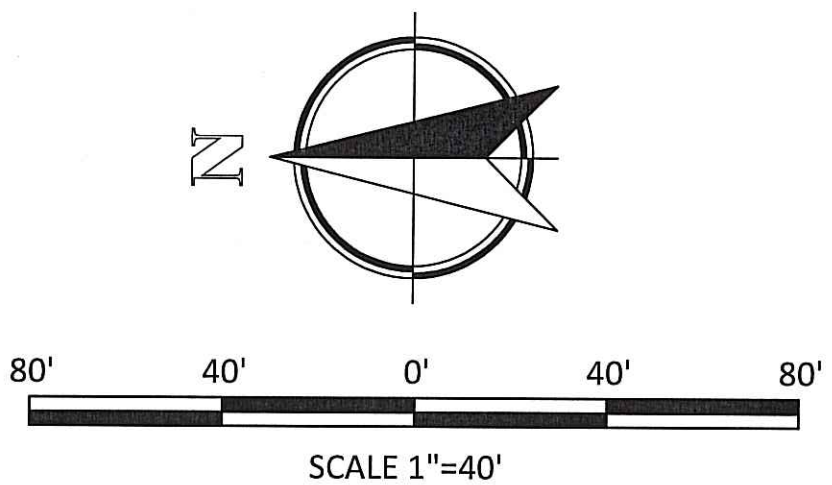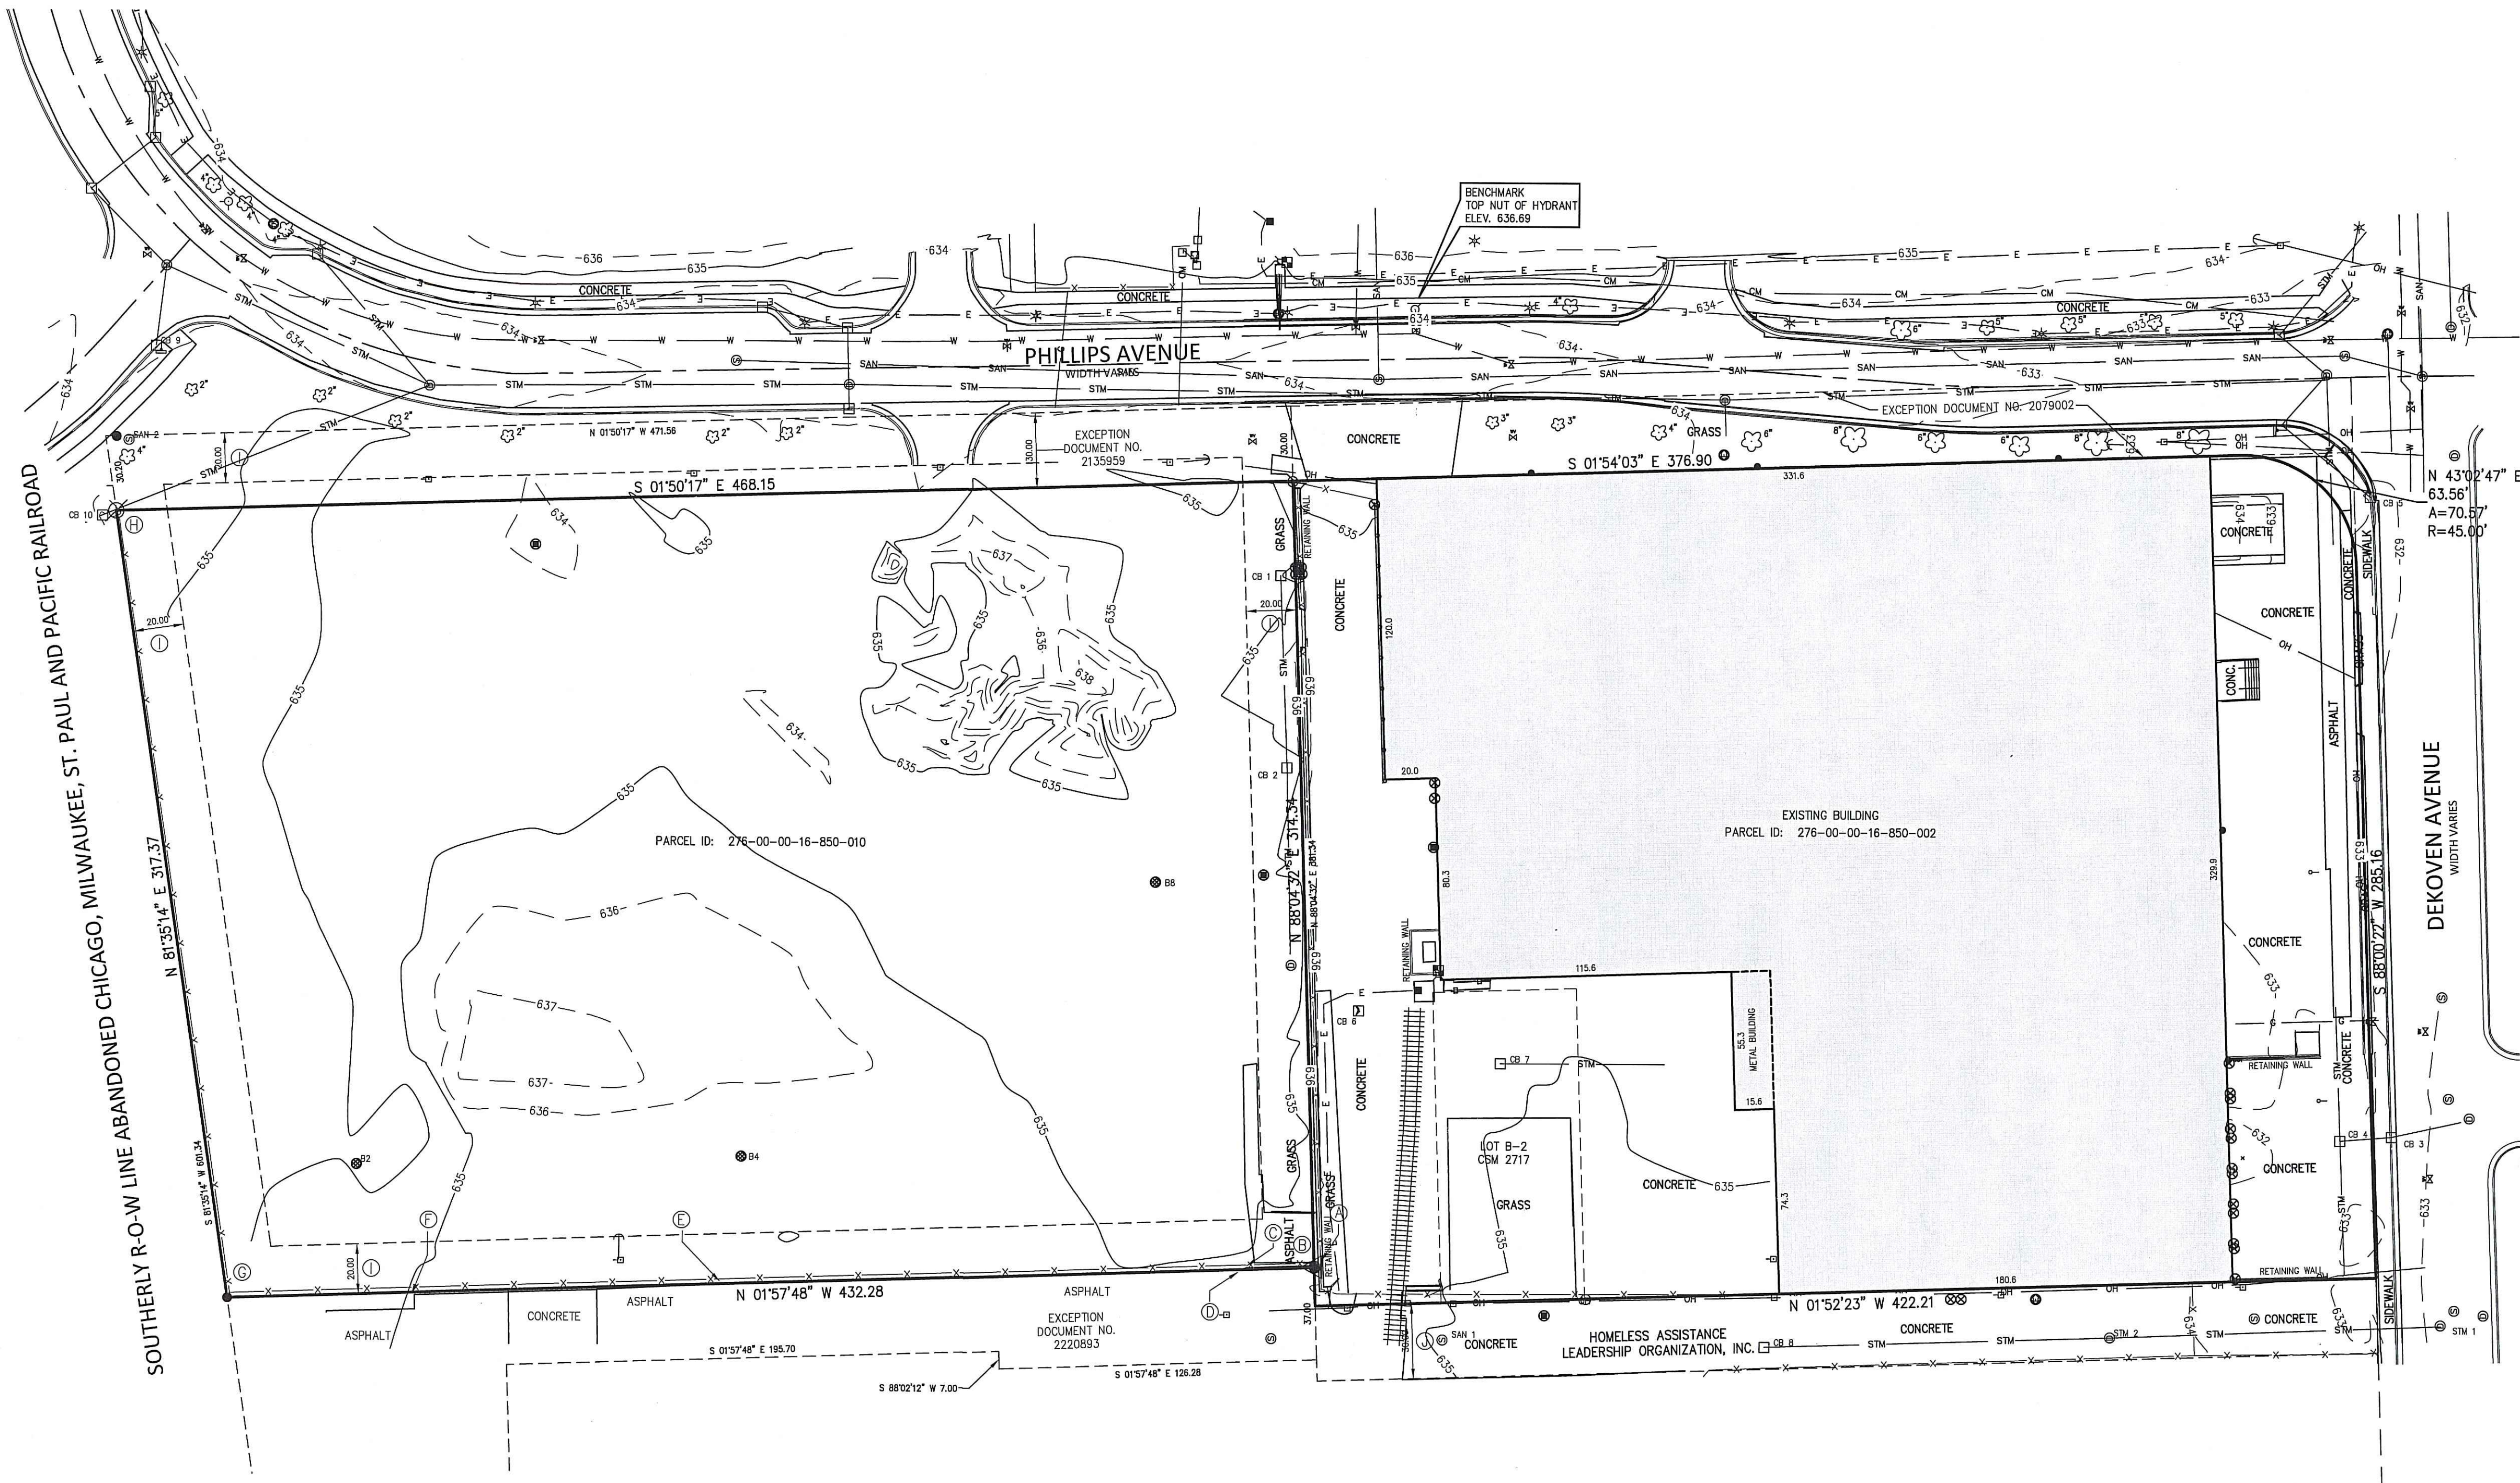

Plat of a survey for the MAYER / HELMINIAK: Parcel B-1 and B-2 of Certified Survey Map No. 2717, recorded in the office of the Register of Deeds for Racine County, Wisconsin on July 22, 2005 in Volume 8 of Certified Survey Maps, Page 634, as Document No. 2034731 and being a re-division of Parcel 2 of Certified Survey Map No. 1703, being a part of the West 1/2 of the Northeast 1/4 of Section 20, Township 3 North, Range 23 East. EXCEPTING THEREFROM land conveyed by deed recorded under Document No. 2220893 and FURTHER EXCEPTING THEREFROM land conveyed by deed recorded under Document No. 2135959. Said land being in the City of Racine, Racine County, Wisconsin. ALSO: That part of the Northeast 1/4 of Section 20, Township 3 North, Range 23 East, bounded as follows: Begin at the intersection of the West line of Phillips Avenue and the North line of Dekoven Avenue; run thence North 421.81 feet on the West line of said Phillips Avenue; thence South 89°58'35" West 329.35 feet; thence South 00°01'40" West 50.00 feet; thence North 89°58'35" East 124.51 feet; thence South 00°01'40" West 57.00 feet; thence South 89°58'35" West 124.51 feet; thence South 00°01'40" West 315.21 feet to a point on the North line of Dekoven Avenue; thence North 89°54'25" East 330.07 feet on the North line of Dekoven Avenue to the point of beginning. EXCEPTING THEREFROM lands conveyed by Warranty Deed recorded on April 3, 2006, as Document No. 2079002. Said land being in the City of Racine, County of Racine and State of Wisconsin.

Certificate
The above-described property has been surveyed under my direction and the map hereon drawn is a correct representation thereof to the best of my knowledge and belief.
03-15-2021 *Walter J. Madsen*
RACINE COUNTY SURVEY


EXISTING UTILITY DATA		
CB 1 RIM 634.83 (STANDING WATER)	CB 6 RIM 634.99	STM 1 RIM 633.24 IE. 12" NW 627.69 IE. 12" SE 627.44
CB 2 RIM 634.96 IE. 8" W 628.81 IE. 8" E 628.76	CB 7 RIM 635.06 IE. 5" S 633.16	STM 2 RIM 633.38 IE. 12" N 626.78 IE. 12" S 626.78 (STANDING WATER)
CB 3 RIM 632.47 IE. 24" S 620.02 IE. 24" N 620.07	CB 8 RIM 634.39 IE. 8" 630.84	SAN 1 RIM 634.63 IE. 5" W 628.53 IE. 8" S 627.73
CB 4 RIM 632.73 IE. 12" W 620.23 IE. 24" E 619.93 IE. 24" S 619.63	CB 9 RIM 633.04 (FROZE SHUT)	SAN 2 RIM 634.19 IE. 8" N 626.84
CB 5 RIM 631.74 IE. 12" NE 628.19	CB 10 RIM 634.37 IE. 15" W 628.12 IE. 15" SE 628.02	

NOTES
BEARING BASE: GRID NORTH, WISCONSIN
COORDINATE SYSTEM, SOUTH ZONE.
BASED UPON NAD 1927
ALL ELEVATIONS REFER TO NATIONAL
GEODETIC DATUM OF 1929.



LEGEND	
STM — STORM SEWER	WATER MANHOLE
— DOWNSPOUT	ELECTRIC PEDESTAL
HYDRANT	ELECTRIC METER
W — WATER MAIN	ELECTRIC LINE
	ELECTRIC MANHOLE
	POWER POLE
	GUY WIRE
	PAD MOUNT TRANSFORMER
	COMMUNICATION MANHOLE
	COMMUNICATION BOX
	COMMUNICATION LINE
	LIGHT POLE
	SANITARY MANHOLE
	SAN — SANITARY SEWER
	MISC. MANHOLE
	SOIL BORING
	GAS MAIN
	GAS VALVE
	SIGN
	GUARD POST
	CLEAN OUT
	DECIDUOUS TREE
	CONIFEROUS TREE
	3/4" REBAR SET
	IRON STAKE FOUND
	HAND RAIL
	FENCE
	OVERHEAD WIRES

- SURVEY NOTES**
- ① EDGE OF ASPHALT 0.72 E. OF PROPERTY CORNER
 - ② FENCE CORNER 0.84 S. 1.18 E. OF PROPERTY CORNER
 - ③ EDGE OF ASPHALT 0.65 E. OF PROPERTY LINE 22.0 N. OF PROPERTY CORNER
 - ④ EDGE OF ASPHALT ON PROPERTY LINE 28.0 N. OF PROPERTY CORNER
 - ⑤ EDGE OF ASPHALT ON PROPERTY LINE 197.0 S. OF PROPERTY CORNER
 - ⑥ EDGE OF ASPHALT 1.0 W. OF PROPERTY LINE 74.0 S. OF PROPERTY CORNER
 - ⑦ FENCE CORNER 0.08 S. 2.02 E. OF PROPERTY CORNER
 - ⑧ FENCE CORNER 1.30 S. 3.19 W. OF PROPERTY CORNER
 - ⑨ W.E.P.CO. & AT&T EASEMENT DOCUMENT NOS. 2155238 & 2226742
 - ⑩ 30' WIDE INGRESS-EGRESS EASEMENT SOUTHERLY TO NORTH LINE DEKOVEN AVENUE (S.M. NO. 2717 PREVIOUSLY DRIVEWAY EASEMENT AREA DOCUMENT NO. 846419)

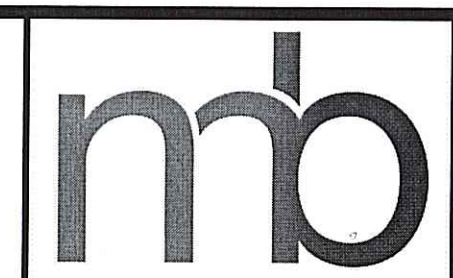

Nielsen Madsen + Barber
CIVIL ENGINEERS AND LAND SURVEYORS
1458 Horizon Blvd. Suite 200, Racine, WI. 53406
Tele: (262)634-5588 Website: www.nmbc.net

**1908 DEKOVEN AVE &
1730 PHILLIPS AVENUE**
EXISTING CONDITIONS PLAN
FOR
MAYER / HELMINIAK
CITY OF RACINE, RACINE COUNTY, WISCONSIN

NO.	REVISION	BY	DATE

PROJ. MGR: MRM
DRAFTED: SCB/ETH
DATE: 3-15-2021
CHECKED: MRM
DATE: 3-15-2021
2020.0288.02
SHEET
1 OF **1**

OWNER



JACQUET
MIDWEST INC.

1908 DE KOVEN STREET
RACINE, WISCONSIN 53403

PROJECT

PHASE 2

REVISIONS
 NO. DATE DESCRIPTION

© MAYER-HELMINIAK ARCHITECTURAL DESIGN
 All Rights Reserved
 OWNERSHIP OF DOCUMENTS
 This document, and the ideas and design incorporated herein, are an instrument of professional service, and the sole property of Mayer-Helminiak Architectural Design, and is not to be used in whole or in part for any other project or purpose without the expressed written authorization of Mayer-Helminiak Architectural Design.

MHA PROJECT # 4035
 PROJ. DATE 06/02/2021
 DRAWN BY
 APPROVED BY


SHEET ISSUE DATE:
 ARCHITECTURAL
 SITE PLAN

A-001




3 STORAGE AREA EXAMPLE

NO SCALE

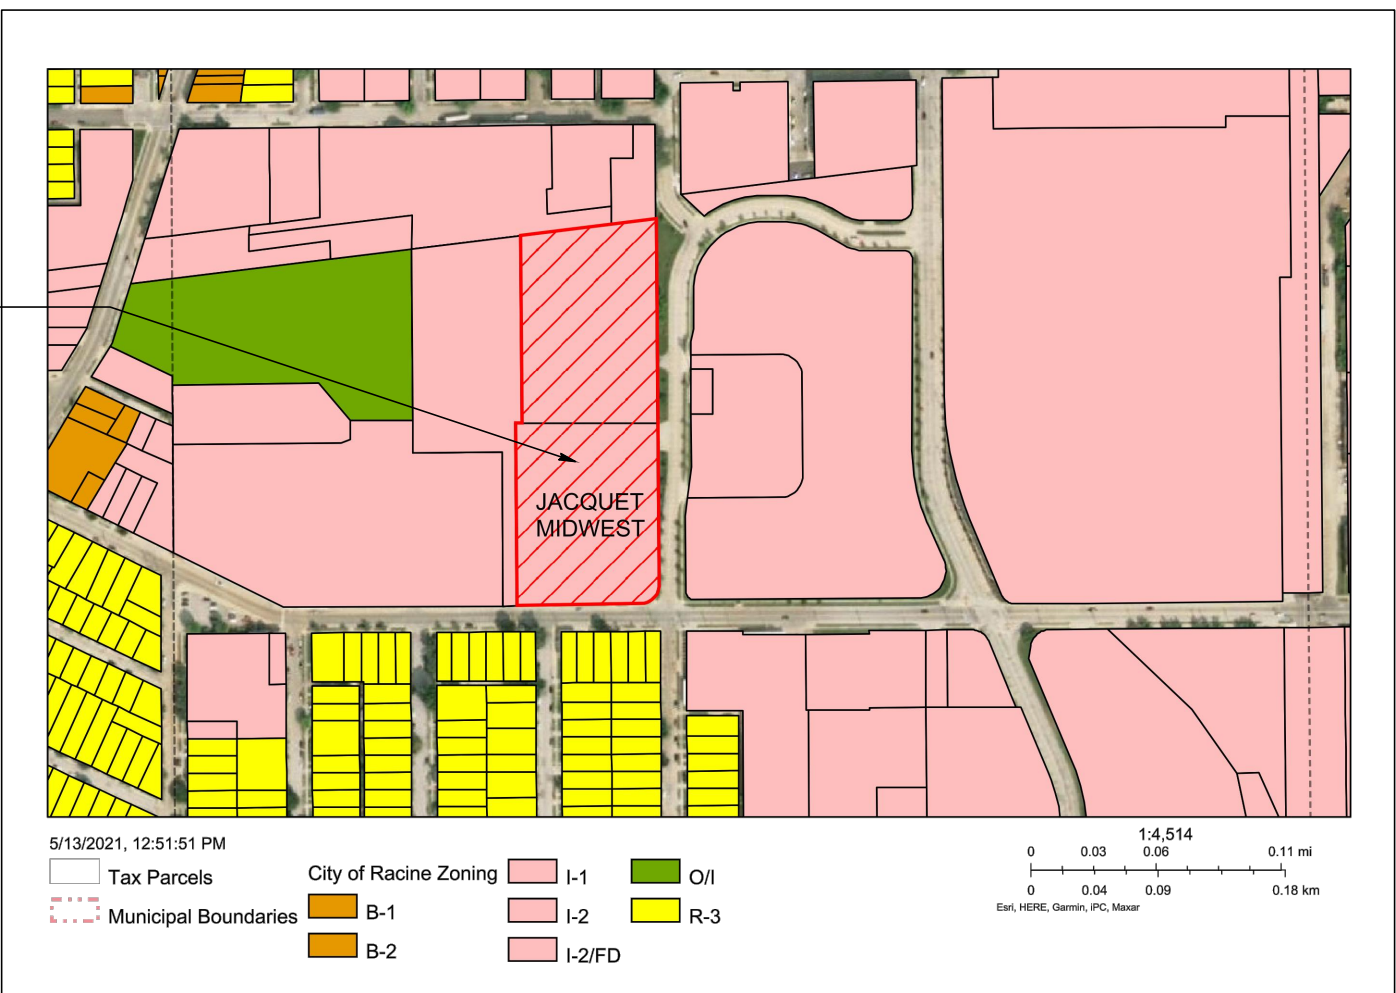

2 ZONING MAP

NO SCALE

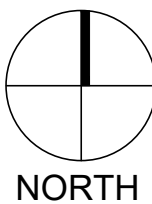

PROJECT DESCRIPTION

JACQUET USA IS A SERVICE ORIENTED STAINLESS AND NICKEL ALLOY PROCESSING COMPANY WITH 7 LOCATIONS STRATEGICALLY PLACED ACROSS THE UNITED STATES AND CANADA, TO PROVIDE FAST TURNAROUND AND DELIVERY. CURRENTLY JACQUET MIDWEST OCCUPIES A FACILITY FOR STORAGE AND PROCESSING OF APPROXIMATELY 80,000 SF, IN ORDER TO PROVIDE ITS CUSTOMERS WITH PRODUCTS FROM STATE-OF-THE-ART FACILITIES JACQUET IS PROPOSING TO DEMOLISH APPROXIMATELY 50,000 SF OF LOW BAY SPACE AND CONSTRUCT APPROXIMATELY 74,000 SF OF CRANE SPACE ALONG WITH A FUTURE OFFICE FACILITY. IN ADDITION TO THE FACILITY JACQUET IS PROPOSING OUTDOOR STORAGE FOR RAW MATERIAL IN A SCREENED AND SECURE AREA, PARKING FOR GUESTS AND EMPLOYEES WILL BE OFF OF DEKOVEN AND WILL PROVIDE APPROXIMATELY 13 SPACES.

CONSTRUCTION IS ANTICIPATED TO START LATE FALL OF 2021 WITH COMPLETION WITHIN A YEAR OF THE PRODUCTION FACILITY.

HOURS OF OPERATION:
1ST SHIFT: 6:00 A.M. - 3:30 P.M.
2ND SHIFT: 3:30 P.M. - 12:00 A.M.
5-6 DAYS PER WEEK.

ANTICIPATED DELIVERY SCHEDULE:
6:00 A.M. - 5:00 P.M. M-FRI.

MAINTENANCE PLAN:
BUILDING IS EXPECTED TO MAINTAIN "LIKE NEW" CONDITION THROUGHOUT LIFESPAN OF JACQUET OWNERSHIP. GROUNDS WILL BE KEPT PROPERLY THROUGH LANDSCAPE COMPANY CURRENTLY USED BY JACQUET MIDWEST.


GENERAL USE OF BUILDING AND LOT:
BUILDING WILL BE USED FOR STAINLESS STEEL AND NICKEL ALLOY PROCESSING MAINLY THROUGH WATERJET, PLASMA, AND LASER CUTTING PROCESSES, BUT NOT LIMITED TO JUST THIS. ADDITIONAL AVAILABLE PROPERTY WILL BE USED FOR OUTSIDE MATERIAL STORAGE

SITE INFORMATION

ZONING	I-2 GENERAL INDUSTRIAL
SITE AREA	6.44 ACRES
SITE	280,552 SF
BUILDING SETBACKS	
FRONT	NOT GREATER THAN 20'
SIDE	NONE
REAR	NONE
FLOOR AREA RATIO	
MAXIMUM PROVIDED	4.00
BUILDING	
EXISTING BUILDING FLOOR AREA	80,089 S.F.
EXISTING BUILDING FLOOR AREA AFTER DEMOLITION	39,796 S.F.
PROPOSED BUILDING ADDITION FLOOR AREA	74,108 S.F.
TOTAL BUILDING FLOOR AREA AFTER NEW CONSTRUCTION	113,905 S.F.
PARKING - CLASS NUMBER 23	8
REQUIRED - 12 EMPLOYEES @ 2 SPACES PER 3 EMPLOYEES PROVIDED	13


DRAWING INDEX


1 of 1	SURVEY
A-001	ARCHITECTURAL SITE PLAN
A-001	EXTERIOR ELEVATIONS
A-002	EXTERIOR ELEVATIONS
A-003	RENDERINGS
A-004	RENDERINGS
A-005	RENDERINGS
A-006	RENDERINGS
A-007	RENDERINGS
A-008	RENDERINGS
A-001	MATERIALS
L-001	LANDSCAPE PLAN
E-001	SITE LIGHTING PLAN

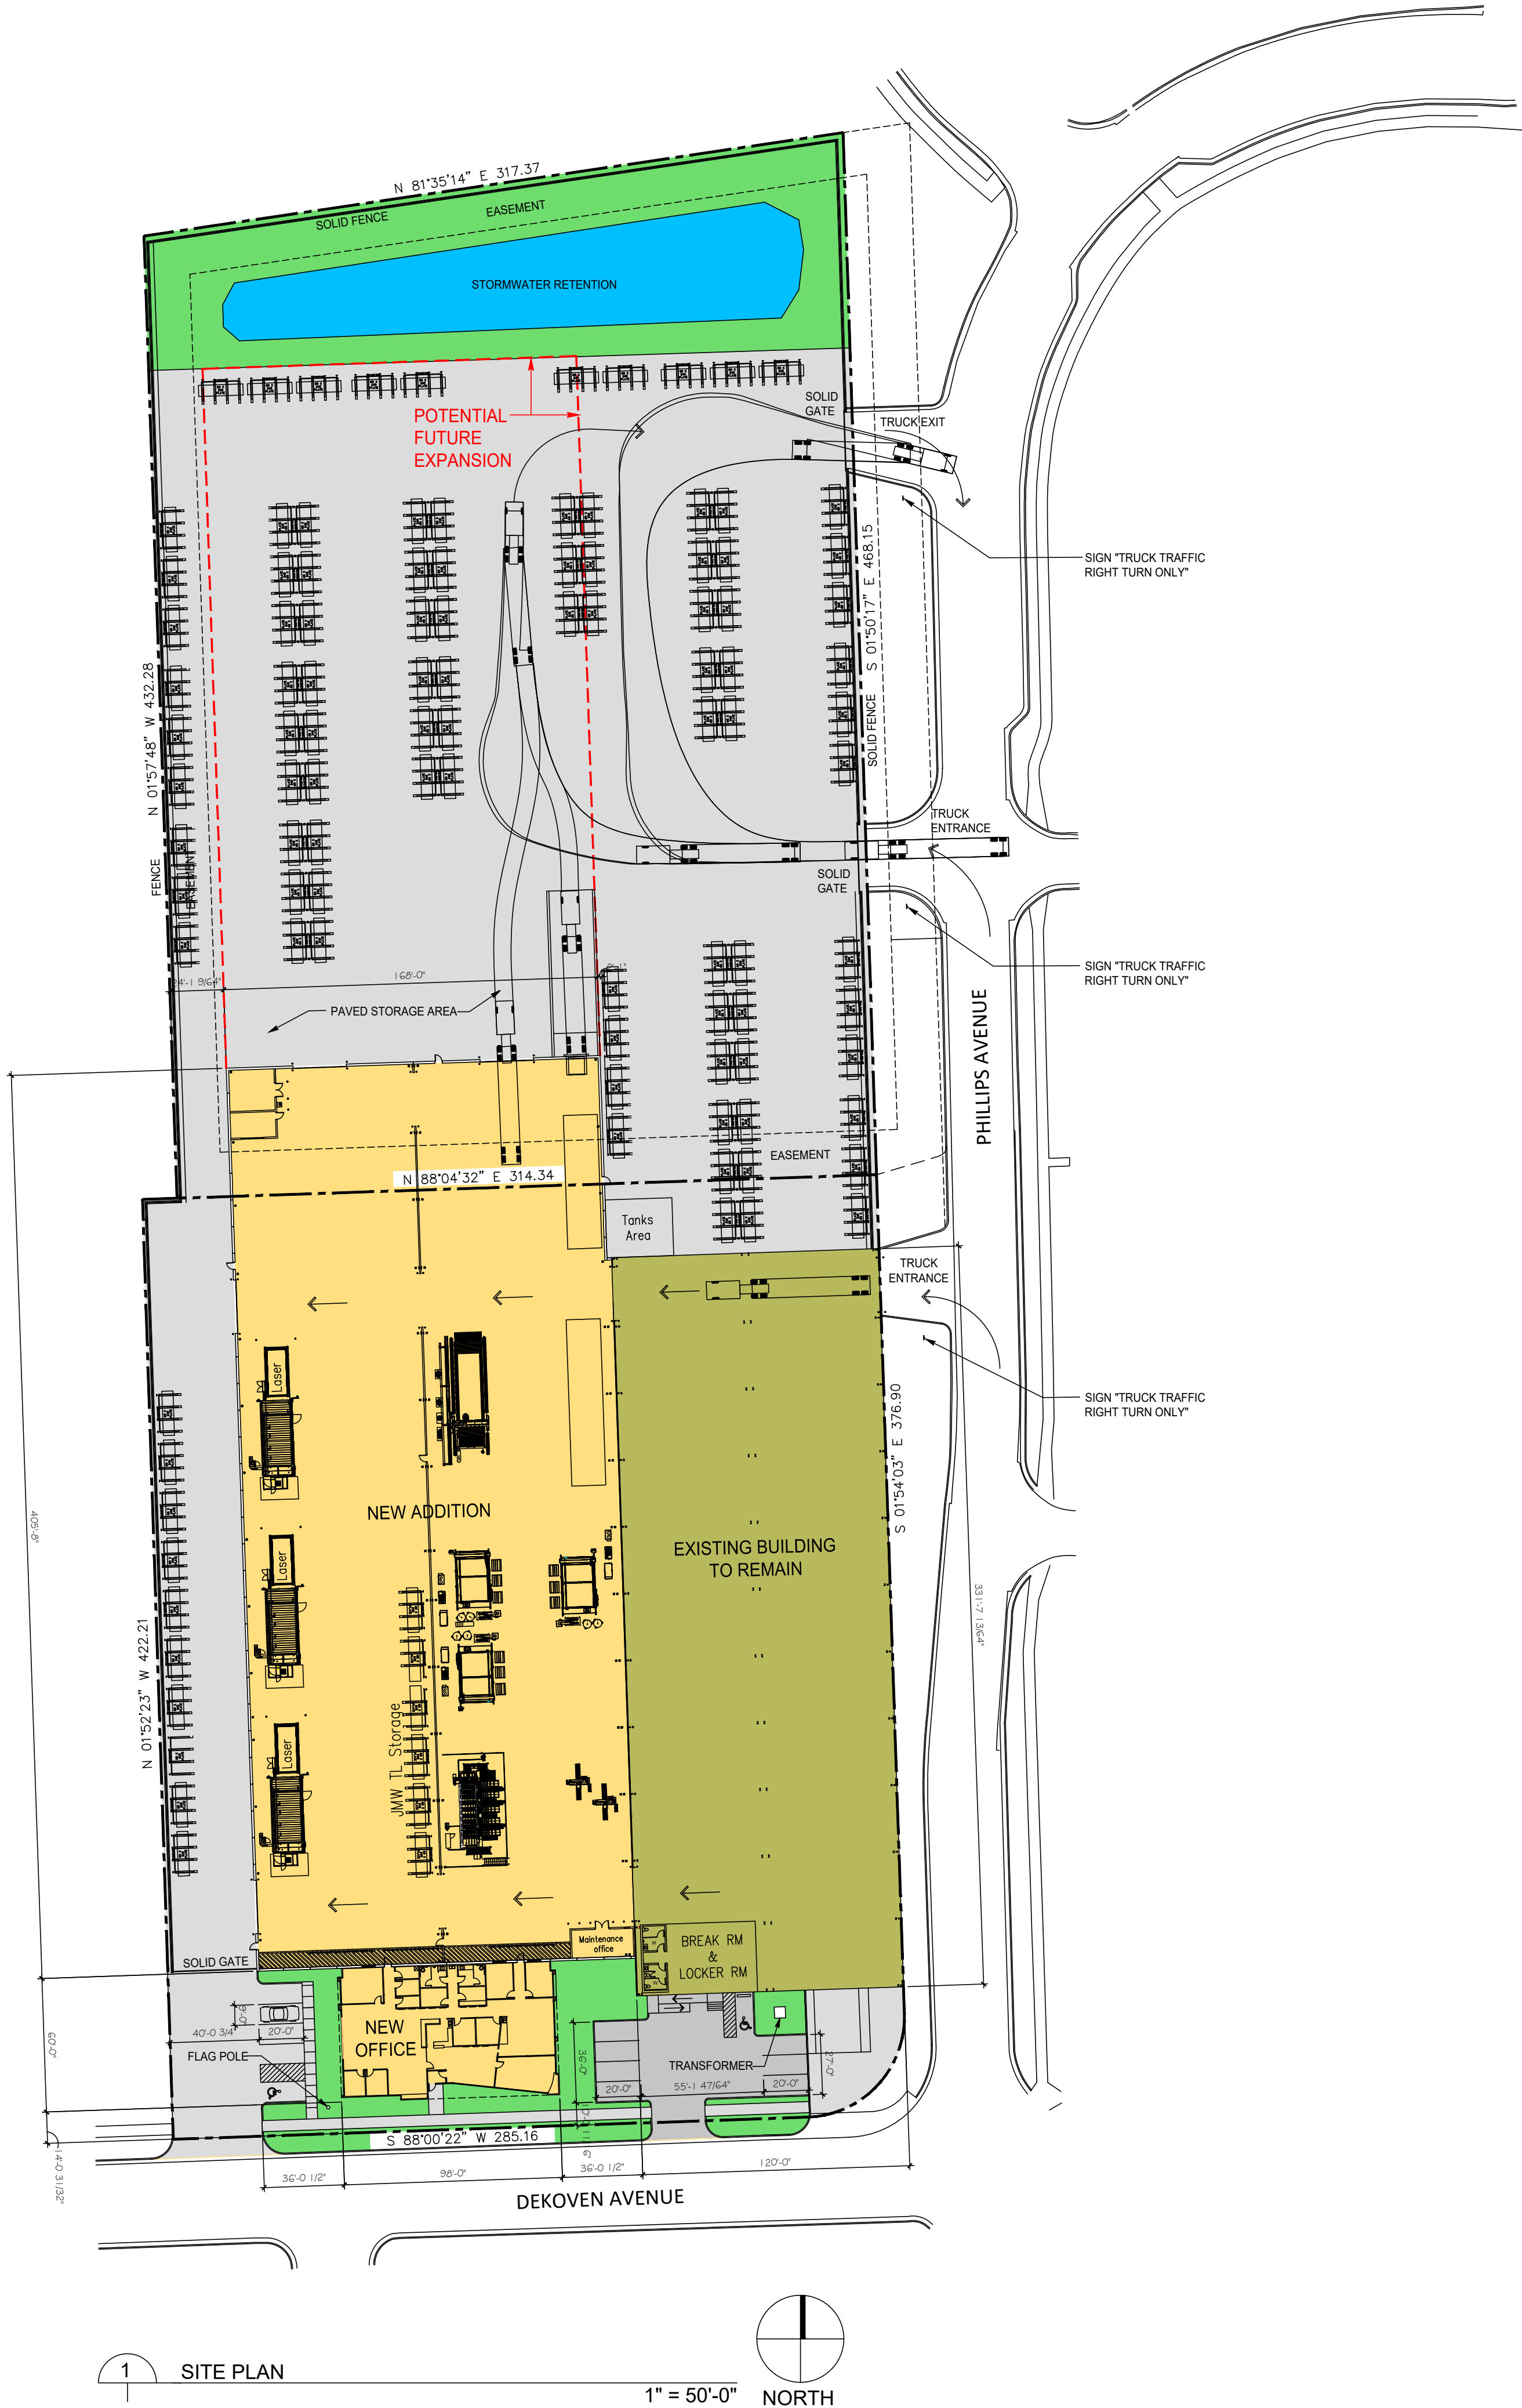

1 SITE PLAN

1" = 50'-0"

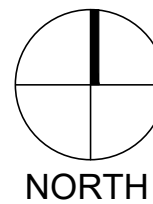

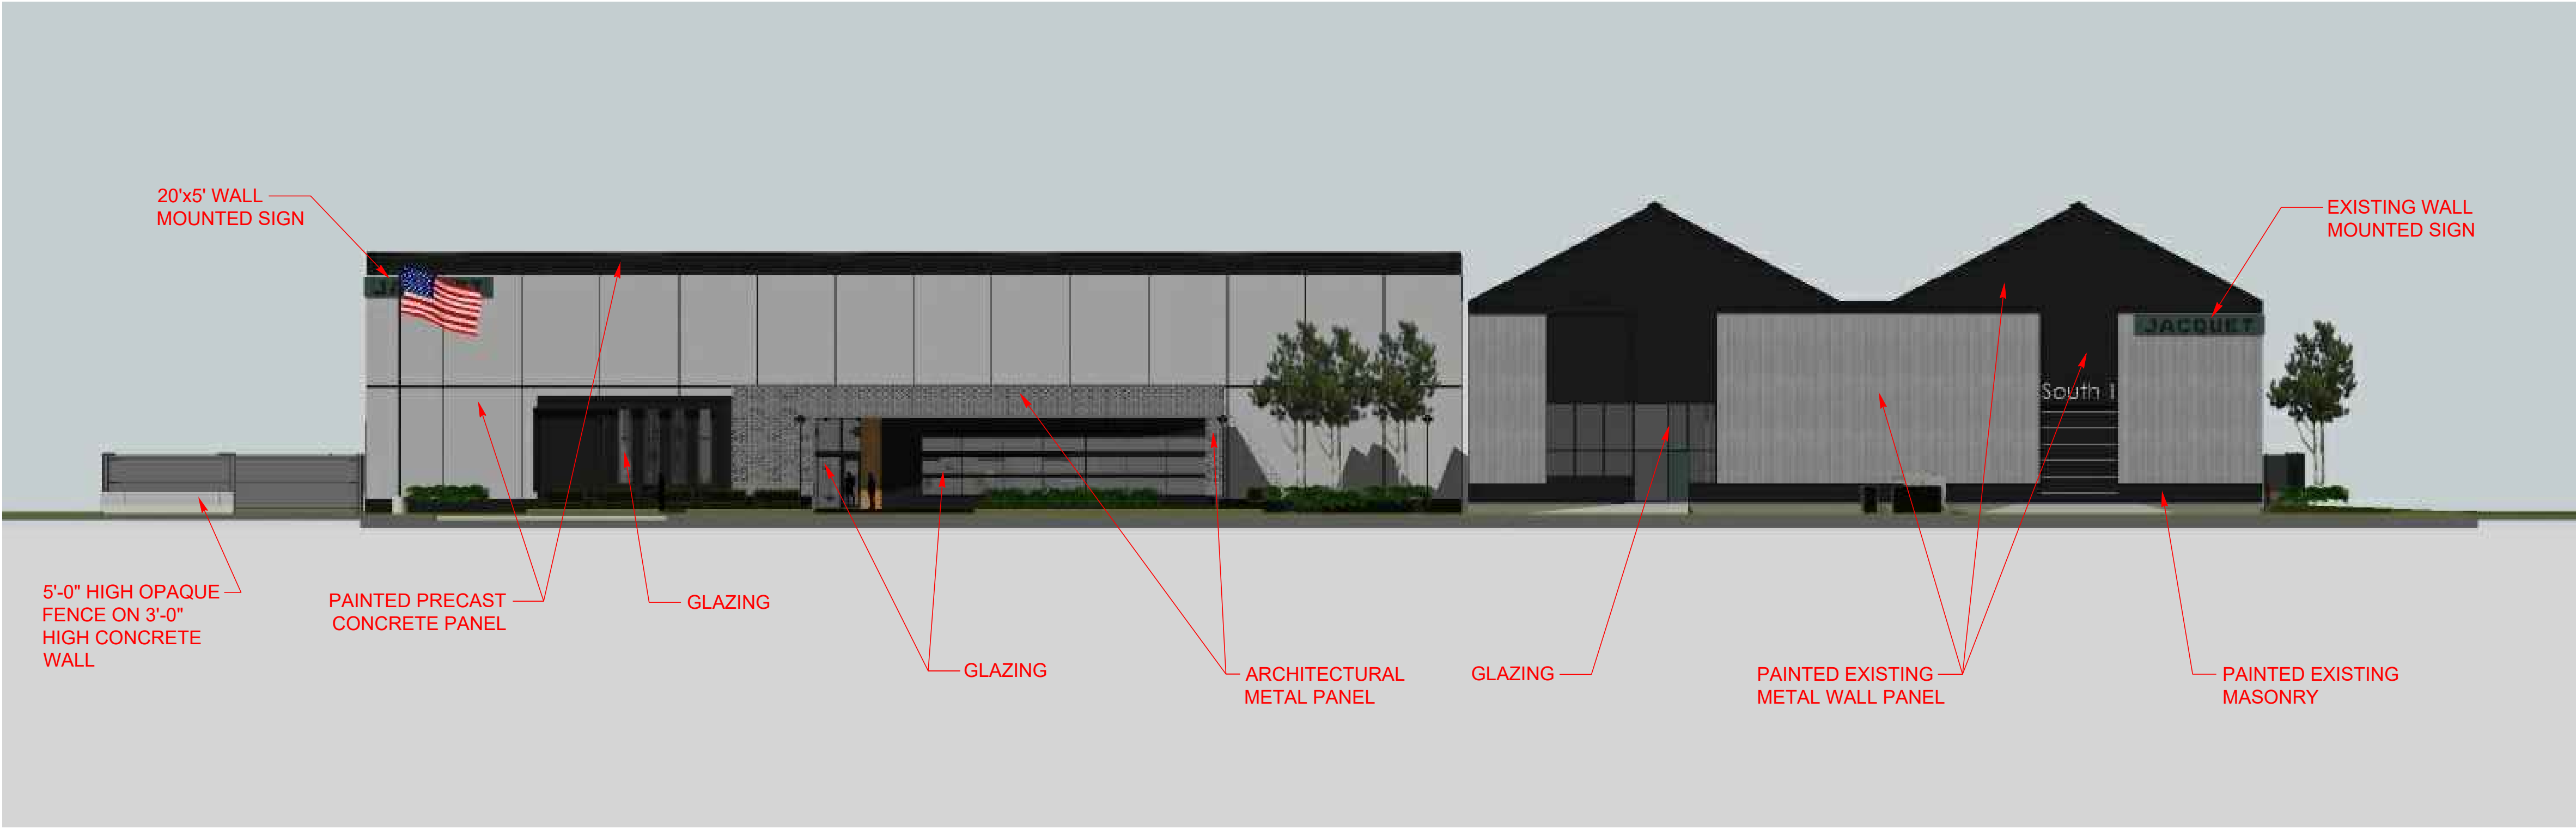

1 SOUTH ELEVATION - OPTION A
1/16" = 1'-0"



2 WEST ELEVATION - OPTION A
1/16" = 1'-0"

OWNER



JACQUET
MIDWEST INC.

1908 DE KOVEN STREET
RACINE, WISCONSIN 53403

PROJECT
PHASE 2

REVISIONS
NO. DATE DESCRIPTION

OPTION A

© MAYER-HELMINIAK ARCHITECTURAL DESIGN
All Rights Reserved
OWNERSHIP OF DOCUMENTS
This document, and the ideas and design incorporated herein, are an instrument of professional service, is the sole property of Mayer-Helminiak Architectural Design, and is not to be used in whole or in part for any other project or purpose without the expressed written authorization of Mayer-Helminiak Architectural Design.


MHA PROJECT # 4035
PROJ. DATE 06/02/2021
DRAWN BY
APPROVED BY

SHEET ISSUE DATE:
EXTERIOR
ELEVATIONS

A-201



3 EAST ELEVATION - OPTION A
1/16" = 1'-0"

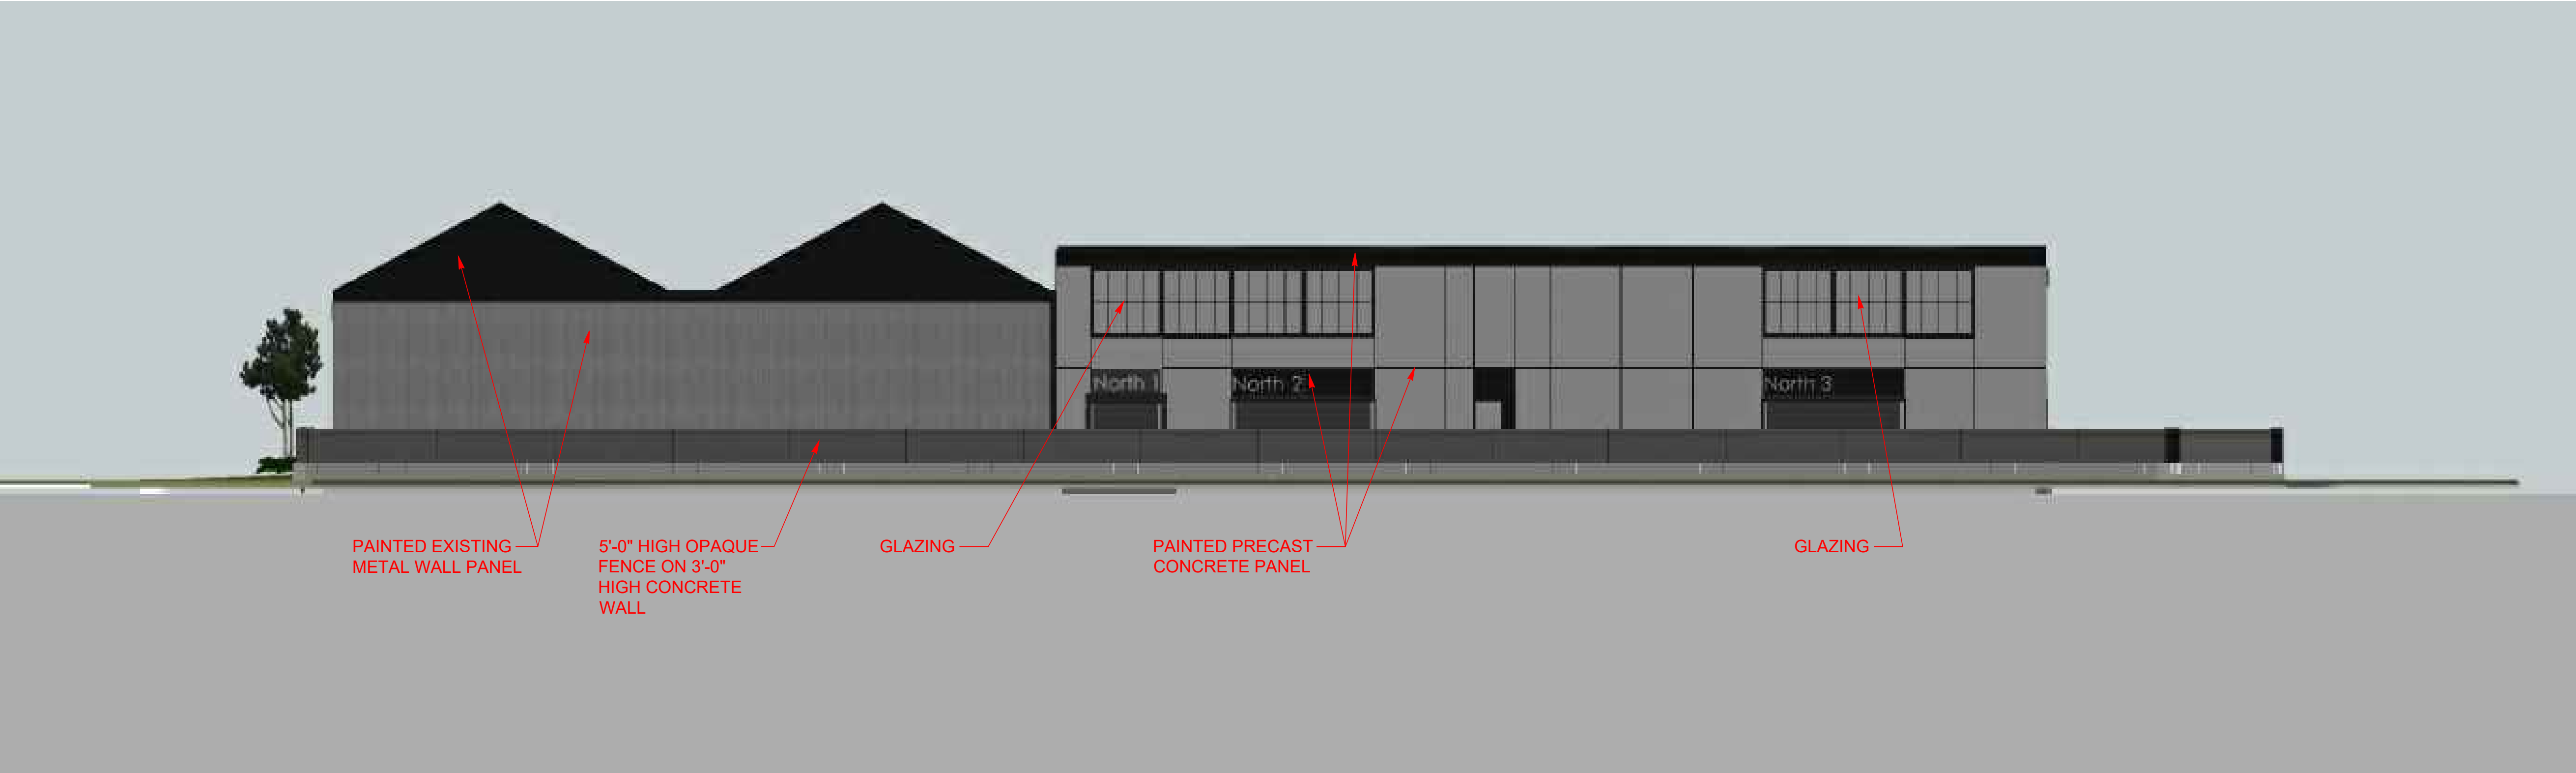

4 NORTH ELEVATION - OPTION A
1/16" = 1'-0"

OWNER

JACQUET

JACQUET
MIDWEST INC.
1908 DE KOVEN STREET
RACINE, WISCONSIN 53403

PROJECT

PHASE 2

REVISIONS

NO. DATE DESCRIPTION

OPTION A

© MAYER-HELMINIAK ARCHITECTURAL DESIGN
All Rights Reserved
OWNERSHIP OF DOCUMENTS
This document, and the ideas and design incorporated herein, as an instrument of professional service, is the sole property of Mayer-Helminiak Architectural Design, and is not to be used in whole or in part for any other project or purpose without the expressed written authorization of Mayer-Helminiak Architectural Design

MHA PROJECT # 4035
PROJ. DATE 06/02/2021
DRAWN BY
APPROVED BY

SHEET ISSUE DATE:
EXTERIOR
ELEVATIONS

A-202



1 AERIAL PERSPECTIVE LOOKING NE - OPTION A
NO SCALE

OWNER

JACQUET

JACQUET
MIDWEST INC.

1908 DE KOVEN STREET
RACINE, WISCONSIN 53403

PROJECT

PHASE 2

REVISIONS

NO. DATE DESCRIPTION

OPTION A

© MAYER-HELMINIAK ARCHITECTURAL DESIGN
All Rights Reserved

OWNERSHIP OF DOCUMENTS

This document, and the ideas and design incorporated herein, as an instrument of professional service, is the sole property of Mayer-Helminiak Architectural Design, and is not to be used in whole or in part for any other project or purpose without the expressed written authorization of Mayer-Helminiak Architectural Design.

MHA PROJECT # 4035
PROJ. DATE 06/02/2021
DRAWN BY
APPROVED BY

SHEET ISSUE DATE:
RENDERINGS

A-203



1 PERSPECTIVE LOOKING NW - OPTION A
NO SCALE

ma
Mayer | Helminiak
Architectural Design
311 East Chicago Street
Suite 310
Milwaukee, WI
53202
(262)241-3700
(262)241-3706 fax
mayer-helminiak.com
CONSULTANT

OWNER

JACQUET

JACQUET
MIDWEST INC.

1908 DE KOVEN STREET
RACINE, WISCONSIN 53403

PROJECT

PHASE 2

REVISIONS

NO. DATE DESCRIPTION

OPTION A

© MAYER-HELMINIAK ARCHITECTURAL DESIGN
All Rights Reserved

OWNERSHIP OF DOCUMENTS

This document, and the ideas and design incorporated herein, as an instrument of professional service, is the sole property of Mayer-Helminiak Architectural Design, and is not to be used in whole or in part for any other project or purpose without the expressed written authorization of Mayer-Helminiak Architectural Design

MHA PROJECT # 4035
PROJ. DATE 06/02/2021
DRAWN BY
APPROVED BY

SHEET ISSUE DATE:
RENDERINGS

A-204



OWNER

JACQUET

JACQUET
MIDWEST INC.

1908 DE KOVEN STREET
RACINE, WISCONSIN 53403

PROJECT
PHASE 2

REVISIONS		
NO.	DATE	DESCRIPTION

OPTION A

© MAYER-HELMINIAK ARCHITECTURAL DESIGN
All Rights Reserved

OWNERSHIP OF DOCUMENTS

This document, and the ideas and design incorporated
herein, as an instrument of professional service, is the
sole property of Mayer-Helminiak Architectural Design,
and is not to be used in whole or in part for any other
project or purpose without the expressed written
authorization of Mayer-Helminiak Architectural Design

MHA PROJECT # 4035
PROJ. DATE 06/02/2021
DRAWN BY
APPROVED BY

SHEET ISSUE DATE:
RENDERINGS

A-205

1 PERSPECTIVE LOOKING NW - OPTION A
NO SCALE



1 PERSPECTIVE LOOKING SW - OPTION A
NO SCALE

ma
Mayer | Helminiak
Architectural Design
311 East Chicago Street
Suite 310
Milwaukee, WI
53202
(262)241-3700
(262)241-3706 fax
mayer-helminiak.com
CONSULTANT

OWNER

JACQUET

JACQUET
MIDWEST INC.

1908 DE KOVEN STREET
RACINE, WISCONSIN 53403

PROJECT

PHASE 2

REVISIONS

NO. DATE DESCRIPTION

OPTION A

© MAYER-HELMINIAK ARCHITECTURAL DESIGN
All Rights Reserved
OWNERSHIP OF DOCUMENTS
This document, and the ideas and design incorporated herein, as an instrument of professional service, is the sole property of Mayer-Helminiak Architectural Design, and is not to be used in whole or in part for any other project or purpose without the expressed written authorization of Mayer-Helminiak Architectural Design

MHA PROJECT # 4035
PROJ. DATE 06/02/2021
DRAWN BY
APPROVED BY

SHEET ISSUE DATE:
RENDERINGS

A-206



OWNER

JACQUET

JACQUET
MIDWEST INC.

1908 DE KOVEN STREET
RACINE, WISCONSIN 53403

PROJECT

PHASE 2

REVISIONS

NO. DATE DESCRIPTION

OPTION A

© MAYER-HELMINIAK ARCHITECTURAL DESIGN
All Rights Reserved
OWNERSHIP OF DOCUMENTS
This document, and the ideas and design incorporated
herein, as an instrument of professional service, is the
sole property of Mayer-Helminiak Architectural Design,
and is not to be used in whole or in part for any other
project or purpose without the expressed written
authorization of Mayer-Helminiak Architectural Design

MHA PROJECT # 4035
PROJ. DATE 06/02/2021
DRAWN BY
APPROVED BY

SHEET ISSUE DATE:
RENDERINGS

A-207

1 PERSPECTIVE LOOKING SE - OPTION A
NO SCALE



1 PERSPECTIVE LOOKING NE - OPTION A
NO SCALE

ma
Mayer | Helminiak
Architectural Design
311 East Chicago Street
Suite 310
Milwaukee, WI
53202
(262)241-3700
(262)241-3706 fax
mayer-helminiak.com
CONSULTANT

OWNER

JACQUET

**JACQUET
MIDWEST INC.**

1908 DE KOVEN STREET
RACINE, WISCONSIN 53403

PROJECT

PHASE 2

REVISIONS

NO. DATE DESCRIPTION

OPTION A

© MAYER-HELMINIAK ARCHITECTURAL DESIGN
All Rights Reserved

OWNERSHIP OF DOCUMENTS

This document, and the ideas and design incorporated herein, as an instrument of professional service, is the sole property of Mayer-Helminiak Architectural Design, and is not to be used in whole or in part for any other project or purpose without the expressed written authorization of Mayer-Helminiak Architectural Design.

MHA PROJECT # 4035
PROJ. DATE 06/02/2021
DRAWN BY
APPROVED BY

SHEET ISSUE DATE:
RENDERINGS

A-208



1 SOUTH ELEVATION - OPTION B
1/16" = 1'-0"



2 WEST ELEVATION - OPTION B
1/16" = 1'-0"

OWNER



JACQUET
MIDWEST INC.
1908 DE KOVEN STREET
RACINE, WISCONSIN 53403

PROJECT
PHASE 2

REVISIONS
NO. DATE DESCRIPTION

OPTION B

© MAYER-HELMINIAK ARCHITECTURAL DESIGN
All Rights Reserved
OWNERSHIP OF DOCUMENTS
This document, and the ideas and design incorporated herein, as an instrument of professional service, is the sole property of Mayer-Helminiak Architectural Design, and is not to be used in whole or in part for any other project or purpose without the expressed written authorization of Mayer-Helminiak Architectural Design.


MHA PROJECT # 4035
PROJ. DATE 06/02/2021
DRAWN BY
APPROVED BY

SHEET ISSUE DATE:
EXTERIOR
ELEVATIONS

A-201



3 EAST ELEVATION - OPTION B
1/16" = 1'-0"

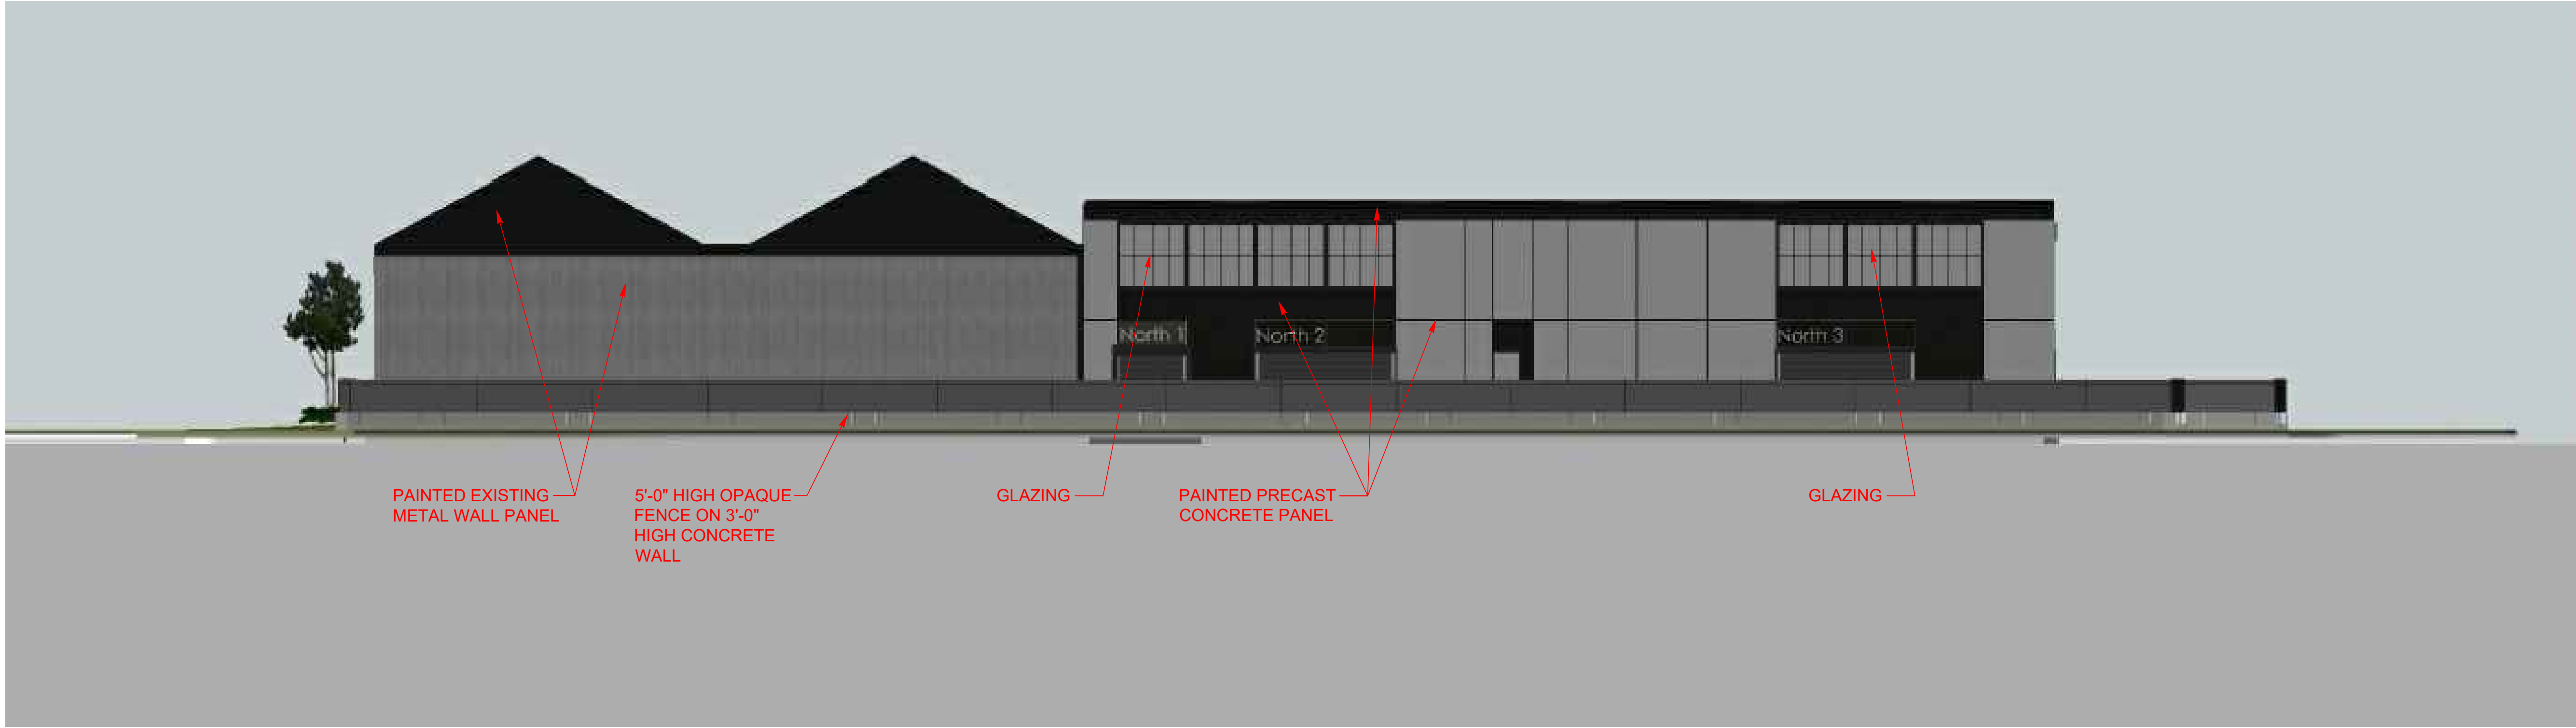

4 NORTH ELEVATION - OPTION B
1/16" = 1'-0"

OWNER

JACQUET

JACQUET
MIDWEST INC.

1908 DE KOVEN STREET
RACINE, WISCONSIN 53403

PROJECT

PHASE 2

REVISIONS

NO.	DATE	DESCRIPTION
-----	------	-------------

OPTION B

© MAYER-HELMINIAK ARCHITECTURAL DESIGN
All Rights Reserved
OWNERSHIP OF DOCUMENTS
This document, and the ideas and design incorporated herein, as an instrument of professional service, is the sole property of Mayer-Helminiak Architectural Design, and is not to be used in whole or in part for any other project or purpose without the expressed written authorization of Mayer-Helminiak Architectural Design

MHA PROJECT #	4035
PROJ. DATE	06/02/2021
DRAWN BY	
APPROVED BY	

SHEET ISSUE DATE:
EXTERIOR
ELEVATIONS

A-202



1 AERIAL PERSPECTIVE LOOKING NE - OPTION B
NO SCALE

OWNER

JACQUET

JACQUET
MIDWEST INC.

1908 DE KOVEN STREET
RACINE, WISCONSIN 53403

PROJECT

PHASE 2

REVISIONS

NO. DATE DESCRIPTION

OPTION B

© MAYER-HELMINIAK ARCHITECTURAL DESIGN
All Rights Reserved

OWNERSHIP OF DOCUMENTS

This document, and the ideas and design incorporated herein, as an instrument of professional service, is the sole property of Mayer-Helminiak Architectural Design, and is not to be used in whole or in part for any other project or purpose without the expressed written authorization of Mayer-Helminiak Architectural Design.

MHA PROJECT # 4035
PROJ. DATE 06/02/2021
DRAWN BY
APPROVED BY

SHEET ISSUE DATE:
RENDERINGS

A-203



1 PERSPECTIVE LOOKING NW - OPTION B
NO SCALE

ma
Mayer | Helminiak
Architectual Design
311 East Chicago Street
Suite 310
Milwaukee, WI
53202
(262)241-3700
(262)241-3706 fax
mayer-helminiak.com
CONSULTANT

OWNER

JACQUET

JACQUET
MIDWEST INC.

1908 DE KOVEN STREET
RACINE, WISCONSIN 53403

PROJECT

PHASE 2

REVISIONS

NO. DATE DESCRIPTION

OPTION B

© MAYER-HELMINIAK ARCHITECTURAL DESIGN
All Rights Reserved

OWNERSHIP OF DOCUMENTS

This document, and the ideas and design incorporated herein, as an instrument of professional service, is the sole property of Mayer-Helminiak Architectural Design, and is not to be used in whole or in part for any other project or purpose without the expressed written authorization of Mayer-Helminiak Architectural Design

MHA PROJECT # 4035
PROJ. DATE 06/02/2021
DRAWN BY
APPROVED BY

SHEET ISSUE DATE:
RENDERINGS

A-204



1 PERSPECTIVE LOOKING SW - OPTION B
NO SCALE

ma
Mayer | Helminiak
Architectural Design
311 East Chicago Street
Suite 310
Milwaukee, WI
53202
(262)241-3700
(262)241-3706 fax
mayer-helminiak.com
CONSULTANT

OWNER

JACQUET

JACQUET
MIDWEST INC.

1908 DE KOVEN STREET
RACINE, WISCONSIN 53403

PROJECT

PHASE 2

REVISIONS

NO. DATE DESCRIPTION

OPTION B

© MAYER-HELMINIAK ARCHITECTURAL DESIGN
All Rights Reserved
OWNERSHIP OF DOCUMENTS
This document, and the ideas and design incorporated herein, as an instrument of professional service, is the sole property of Mayer-Helminiak Architectural Design, and is not to be used in whole or in part for any other project or purpose without the expressed written authorization of Mayer-Helminiak Architectural Design

MHA PROJECT # 4035
PROJ. DATE 06/02/2021
DRAWN BY
APPROVED BY

SHEET ISSUE DATE:
RENDERINGS

A-206



OWNER

JACQUET

JACQUET
MIDWEST INC.

1908 DE KOVEN STREET
RACINE, WISCONSIN 53403

PROJECT

PHASE 2

REVISIONS

NO.	DATE	DESCRIPTION
-----	------	-------------

OPTION B

© MAYER-HELMINIAK ARCHITECTURAL DESIGN
All Rights Reserved
OWNERSHIP OF DOCUMENTS
This document, and the ideas and design incorporated
herein, as an instrument of professional service, is the
sole property of Mayer-Helminiak Architectural Design,
and is not to be used in whole or in part for any other
project or purpose without the expressed written
authorization of Mayer-Helminiak Architectural Design

MHA PROJECT #	4035
PROJ. DATE	06/02/2021
DRAWN BY	
APPROVED BY	

SHEET ISSUE DATE:
RENDERINGS

A-207

1 PERSPECTIVE LOOKING SE - OPTION B
NO SCALE



1 PERSPECTIVE LOOKING NE - OPTION B
NO SCALE

OWNER

JACQUET

JACQUET
MIDWEST INC.

1908 DE KOVEN STREET
RACINE, WISCONSIN 53403

PROJECT

PHASE 2

REVISIONS

NO. DATE DESCRIPTION

OPTION B

© MAYER-HELMINIAK ARCHITECTURAL DESIGN
All Rights Reserved

OWNERSHIP OF DOCUMENTS

This document, and the ideas and design incorporated herein, as an instrument of professional service, is the sole property of Mayer-Helminiak Architectural Design, and is not to be used in whole or in part for any other project or purpose without the expressed written authorization of Mayer-Helminiak Architectural Design

MHA PROJECT # 4035
PROJ. DATE 06/02/2021
DRAWN BY
APPROVED BY

SHEET ISSUE DATE:
RENDERINGS

A-208

OWNER

JACQUET

JACQUET
MIDWEST INC.

1908 DE KOVEN STREET
RACINE, WISCONSIN 53403

PROJECT

PHASE 2

REVISIONS

NO.	DATE	DESCRIPTION
-----	------	-------------

© MAYER-HELMINIAK ARCHITECTURAL DESIGN
All Rights Reserved


OWNERSHIP OF DOCUMENTS

This document, and the ideas and design incorporated herein, as an instrument of professional service, is the sole property of Mayer-Helminiak Architectural Design, and is not to be used in whole or in part for any other project or purpose without the expressed written authorization of Mayer-Helminiak Architectural Design

MHA PROJECT #	4035
PROJ. DATE	06/02/2021
DRAWN BY	
APPROVED BY	

SHEET ISSUE DATE:
MATERIALS

A-301

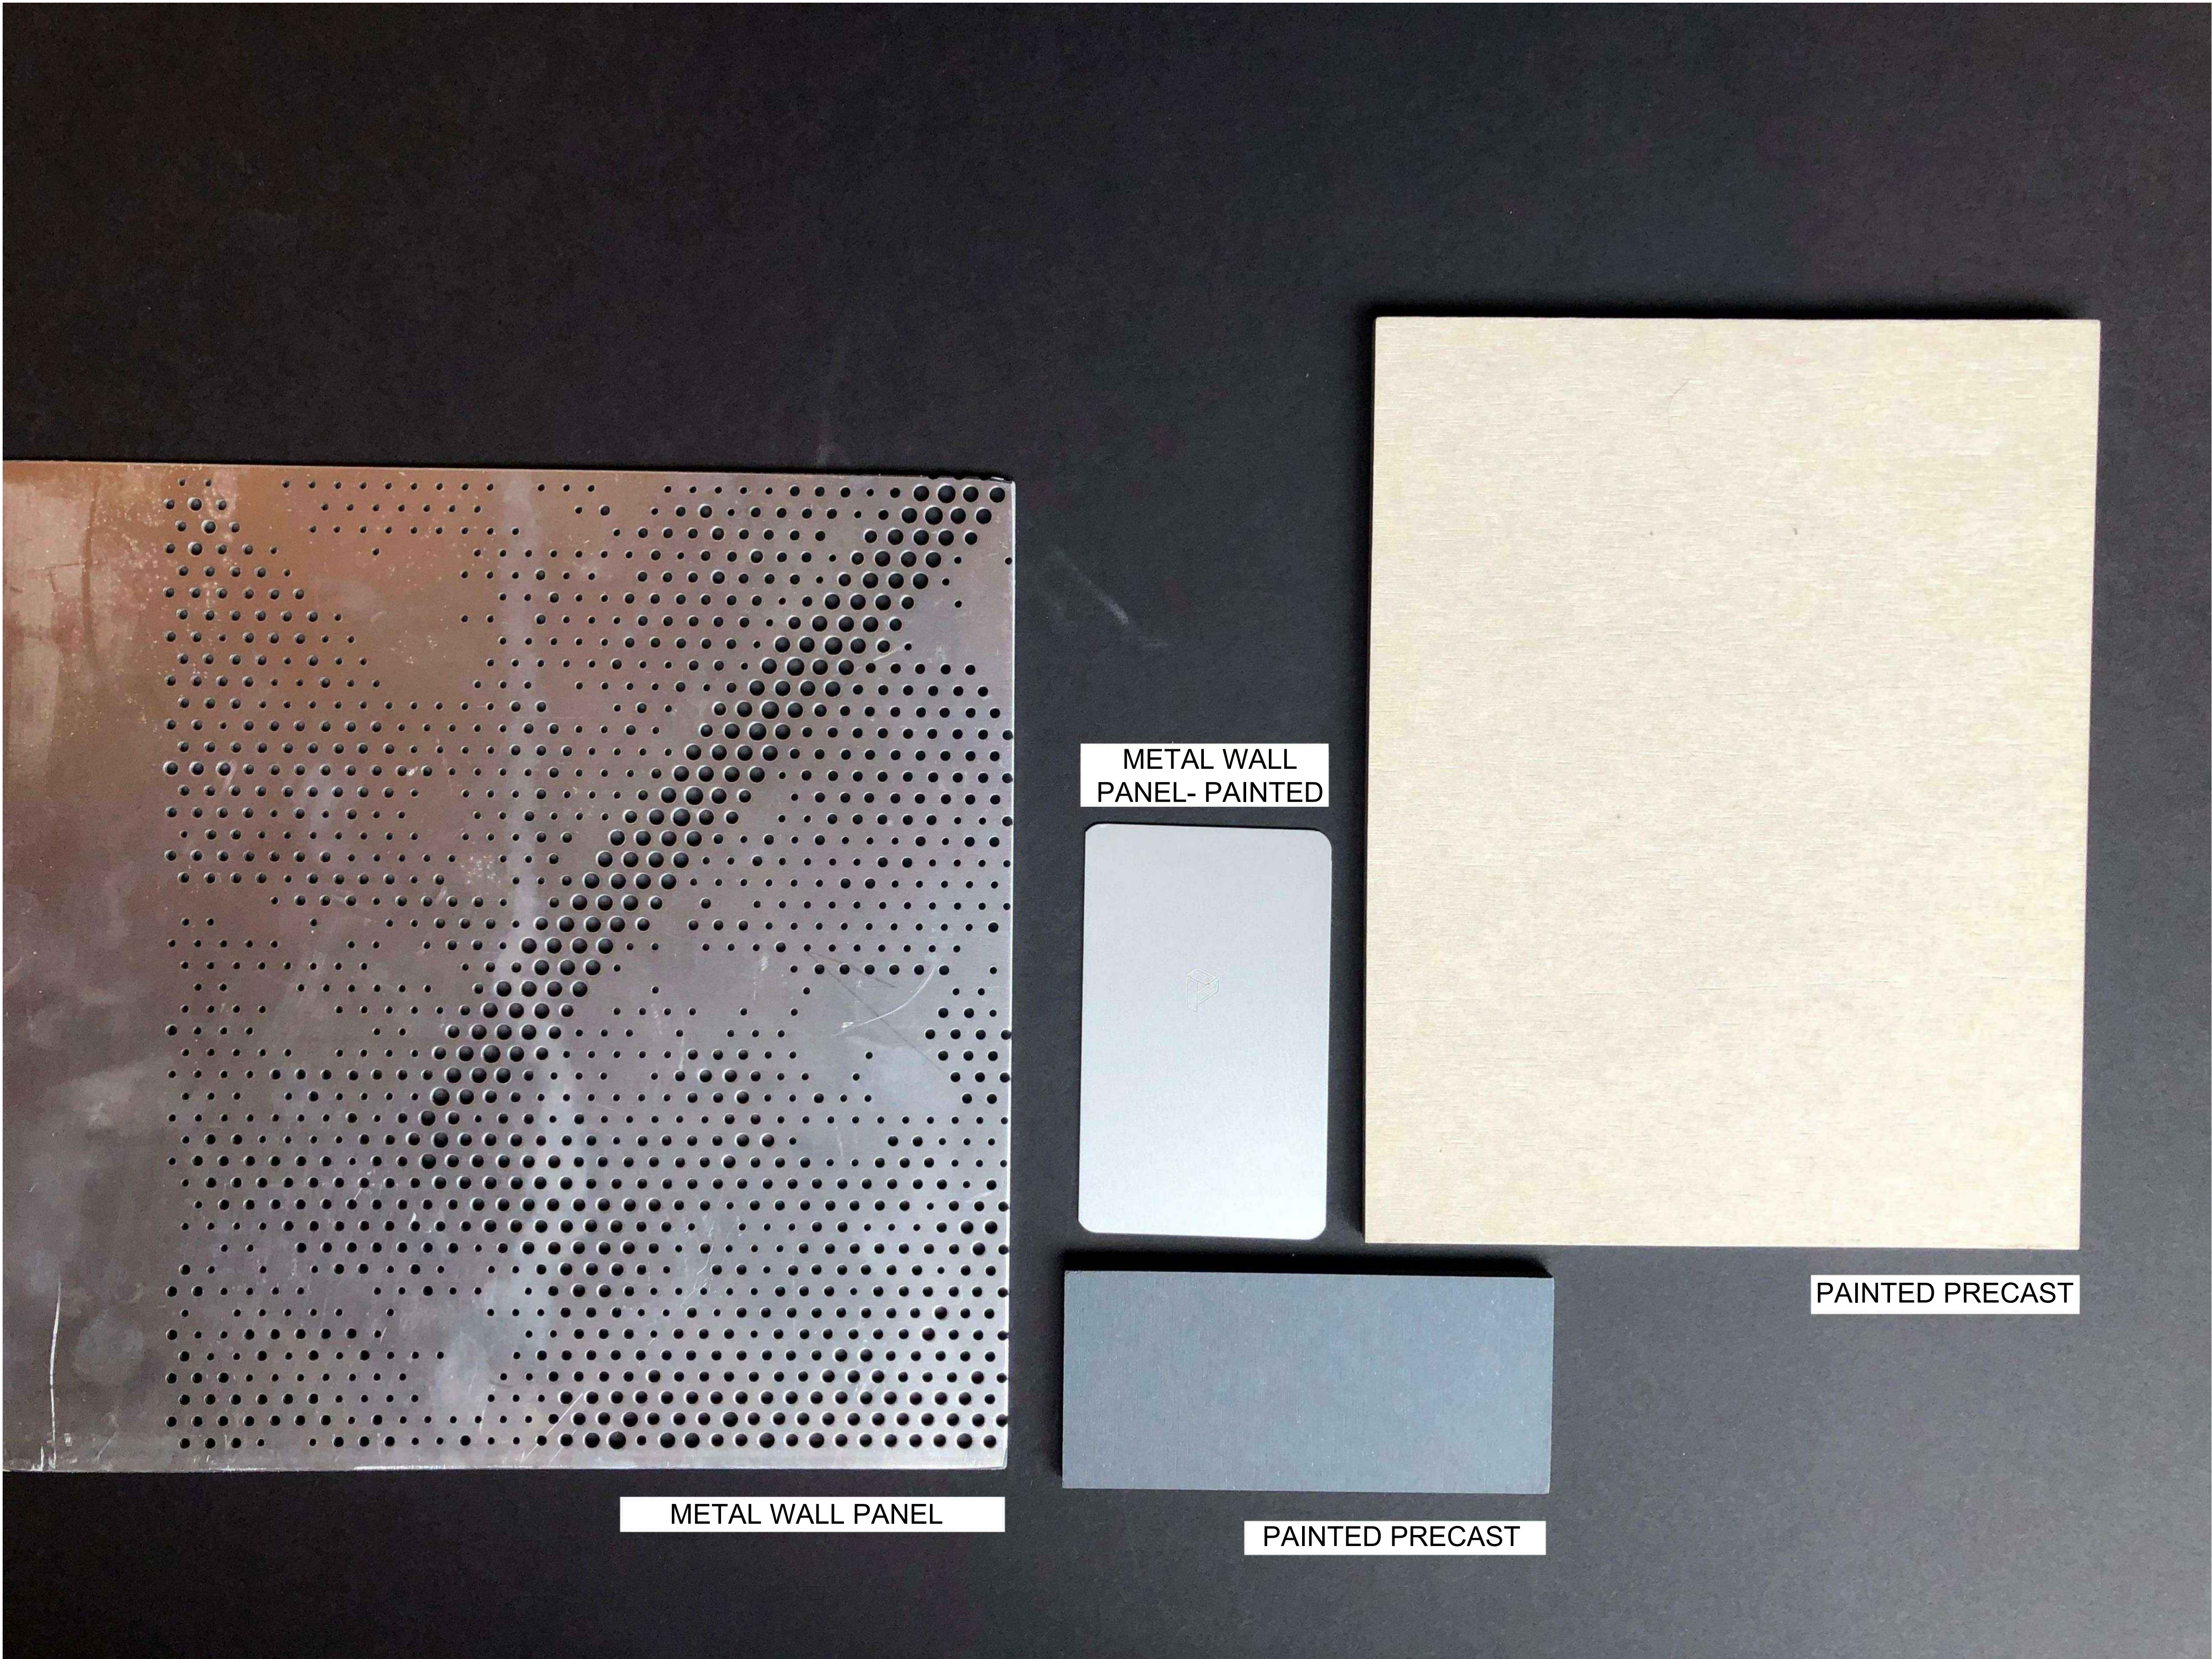

METAL WALL
PANEL- PAINTED

PAINTED PRECAST

METAL WALL PANEL

PAINTED PRECAST

1 MATERIALS
NO SCALE

OWNER

JACQUET

JACQUET
MIDWEST INC.

1908 DE KOVEN STREET
RACINE, WISCONSIN 53403

PROJECT

PHASE 2

REVISIONS

NO. DATE DESCRIPTION

© MAYER-HELMINIAK ARCHITECTURAL DESIGN
All Rights Reserved


OWNERSHIP OF DOCUMENTS

This document, and the ideas and design incorporated herein, as an instrument of professional service, is the sole property of Mayer-Helminiak Architectural Design, and is not to be used in whole or in part for any other project or purpose without the expressed written authorization of Mayer-Helminiak Architectural Design

MHA PROJECT # 4035
PROJ. DATE 06/02/2021
DRAWN BY
APPROVED BY


SHEET ISSUE DATE:
LANDSCAPE
PLAN

L-001

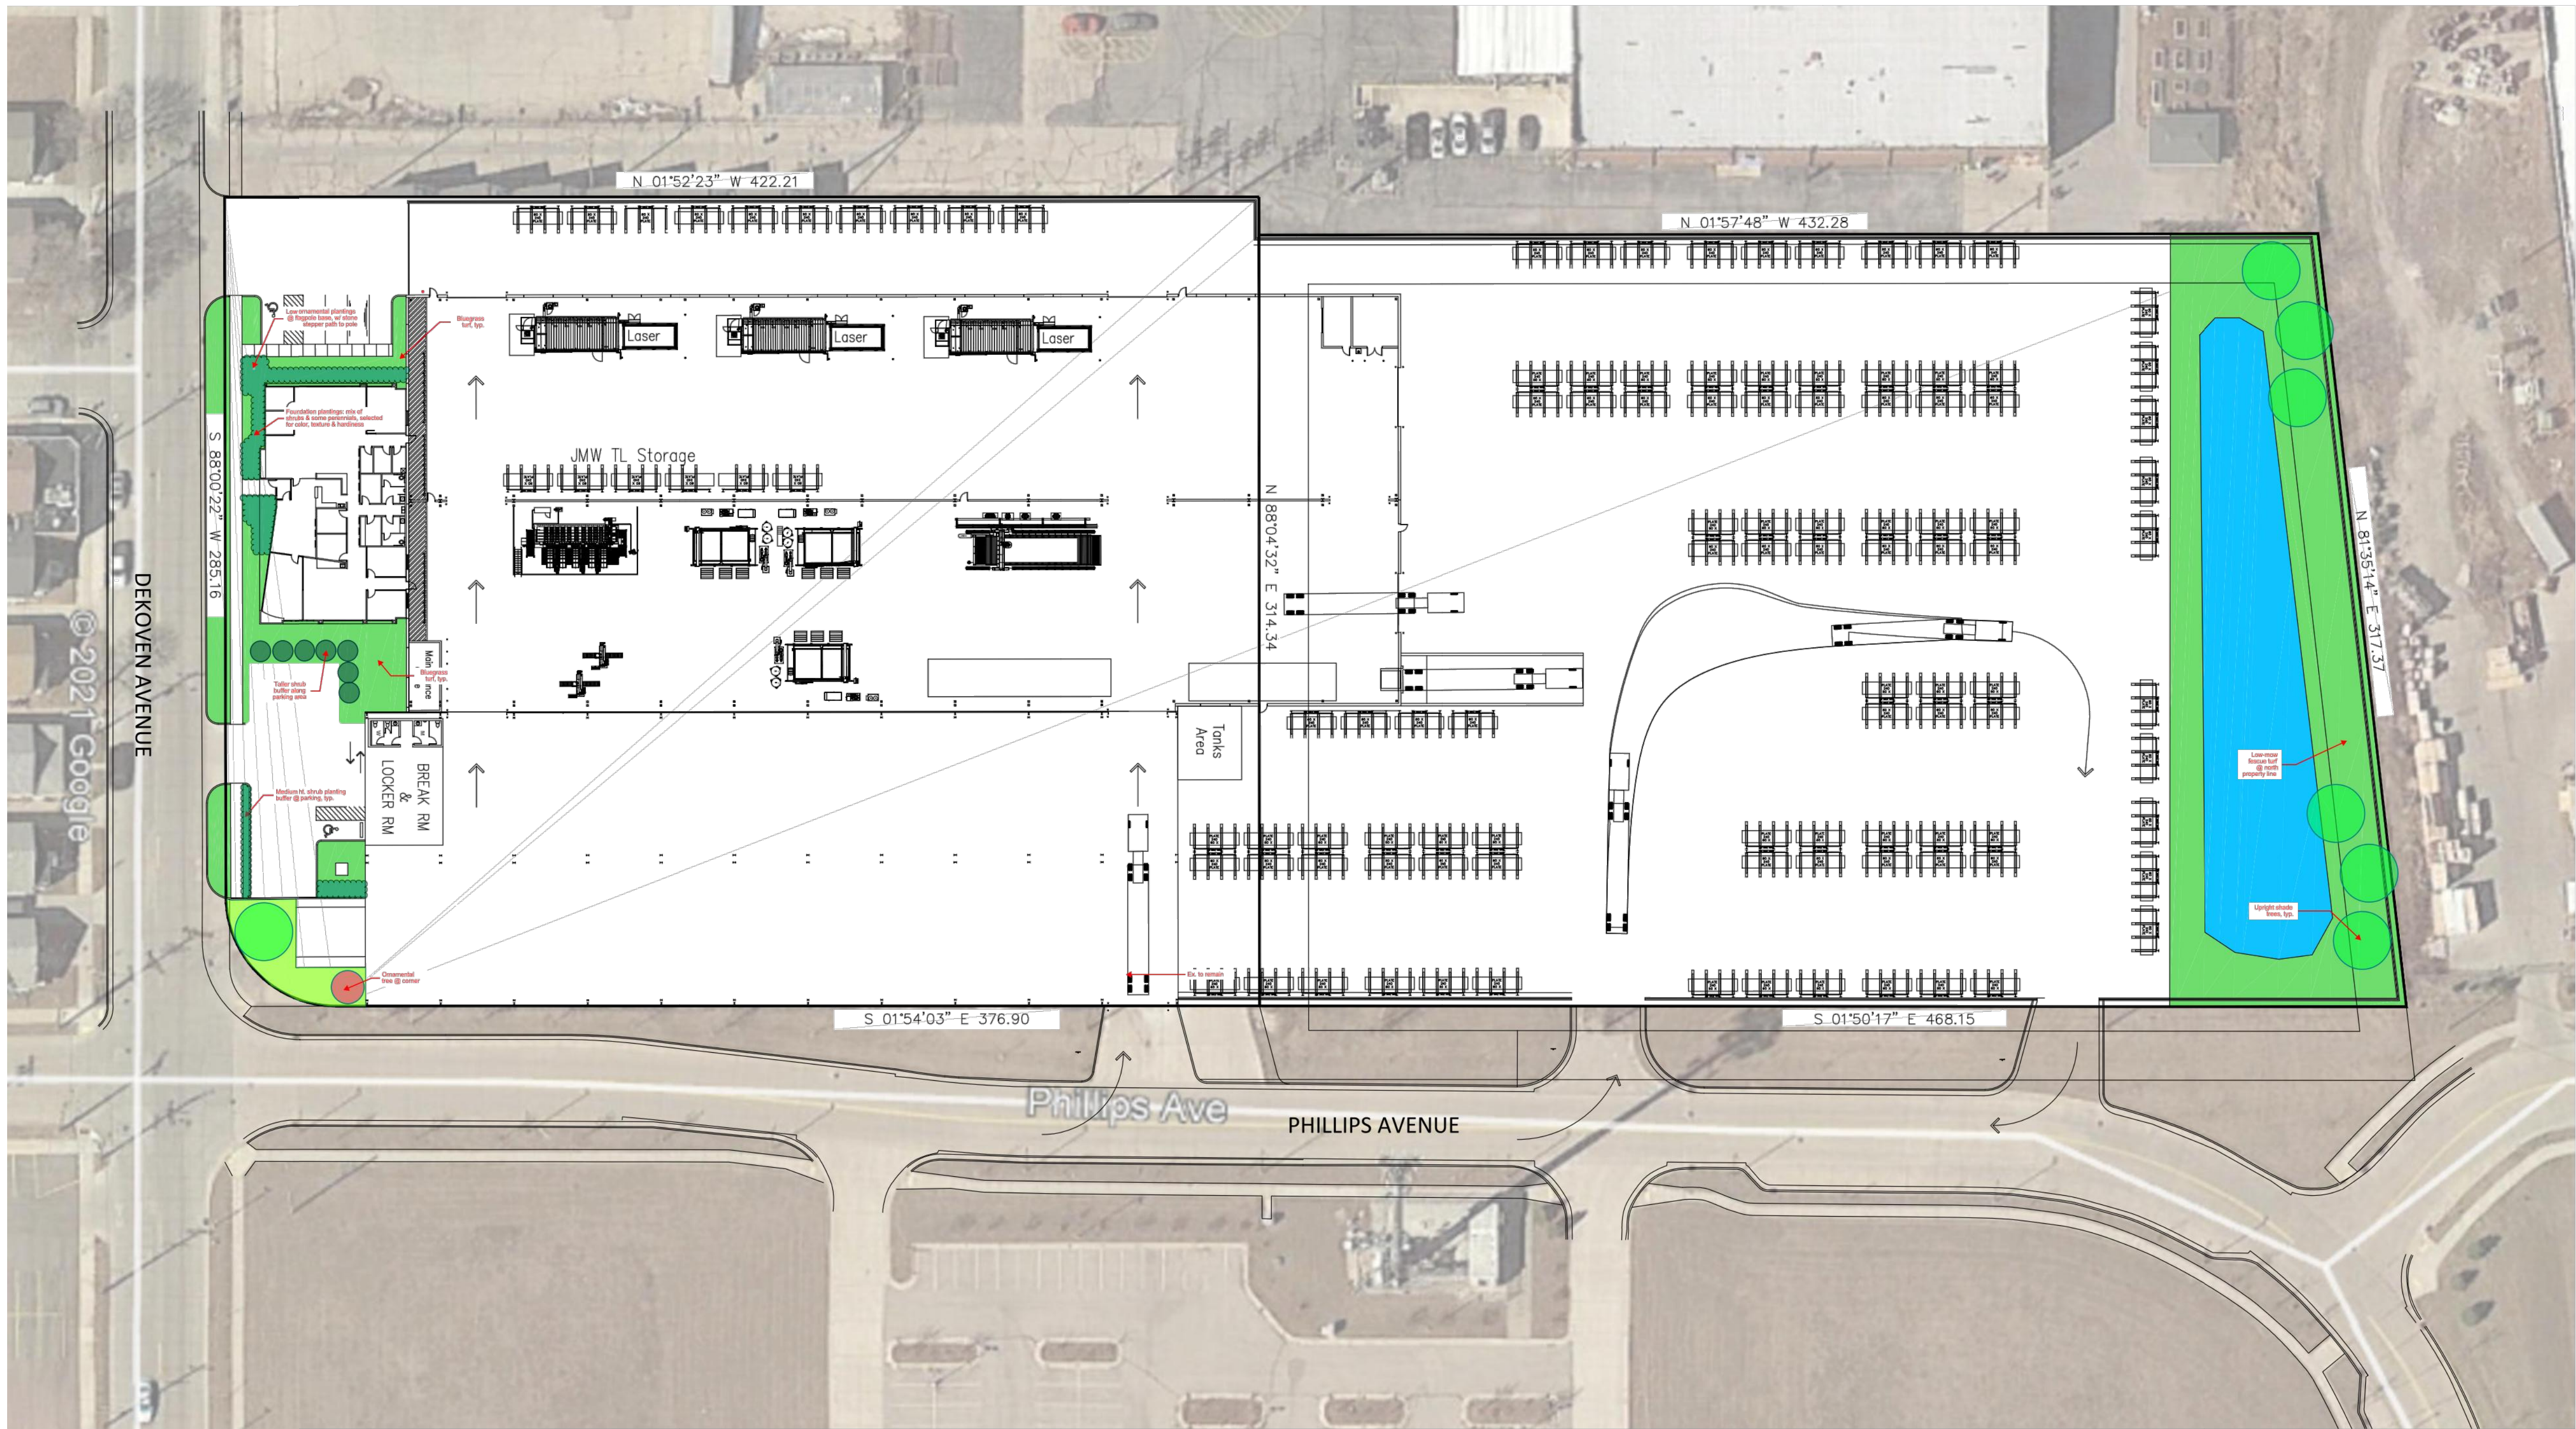

1 LANDSCAPE PLAN

1" = 40'-0"

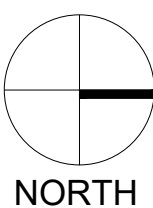

OWNER

JACQUET

JACQUET
MIDWEST INC.

1908 DE KOVEN STREET
RACINE, WISCONSIN 53403

PROJECT

PHASE 2

REVISIONS
 NO. DATE DESCRIPTION

© MAYER-HELMINIAK ARCHITECTURAL DESIGN
 All Rights Reserved
 OWNERSHIP OF DOCUMENTS
 This document, and the ideas and design incorporated herein, as an instrument of professional service, is the sole property of Mayer-Helminiak Architectural Design, and is not to be used in whole or in part for any other project or purpose without the expressed written authorization of Mayer-Helminiak Architectural Design


MHA PROJECT # 4035
 PROJ. DATE 05/26/2021
 DRAWN BY
 APPROVED BY

SHEET ISSUE DATE:
 SITE LIGHTING
 PLAN



E-001



3 STORAGE AREA EXAMPLE
NO SCALE

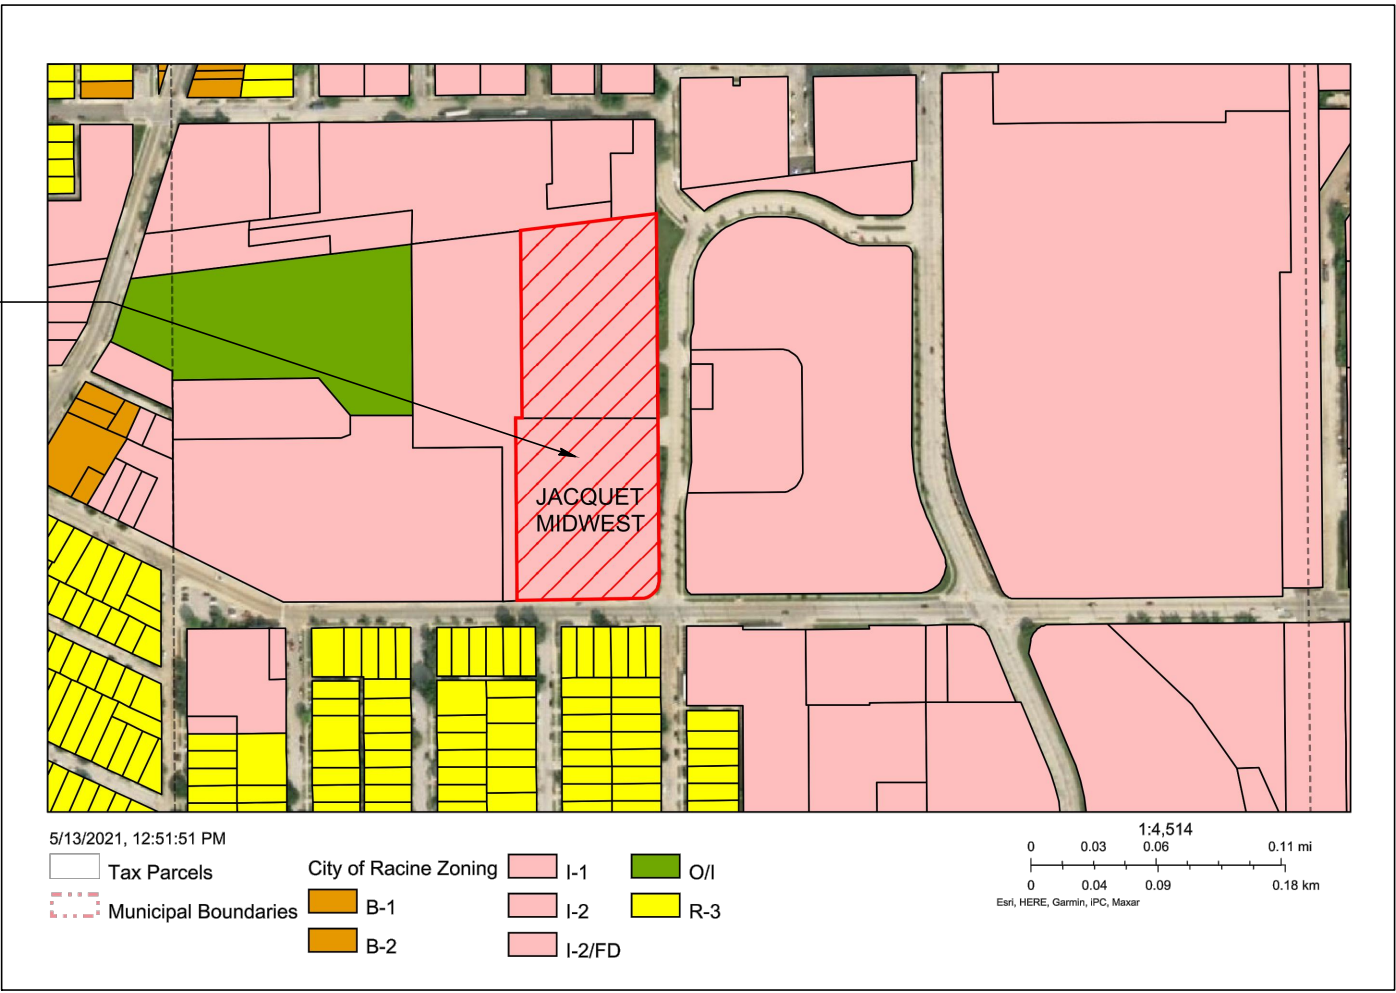

2 ZONING MAP
NO SCALE

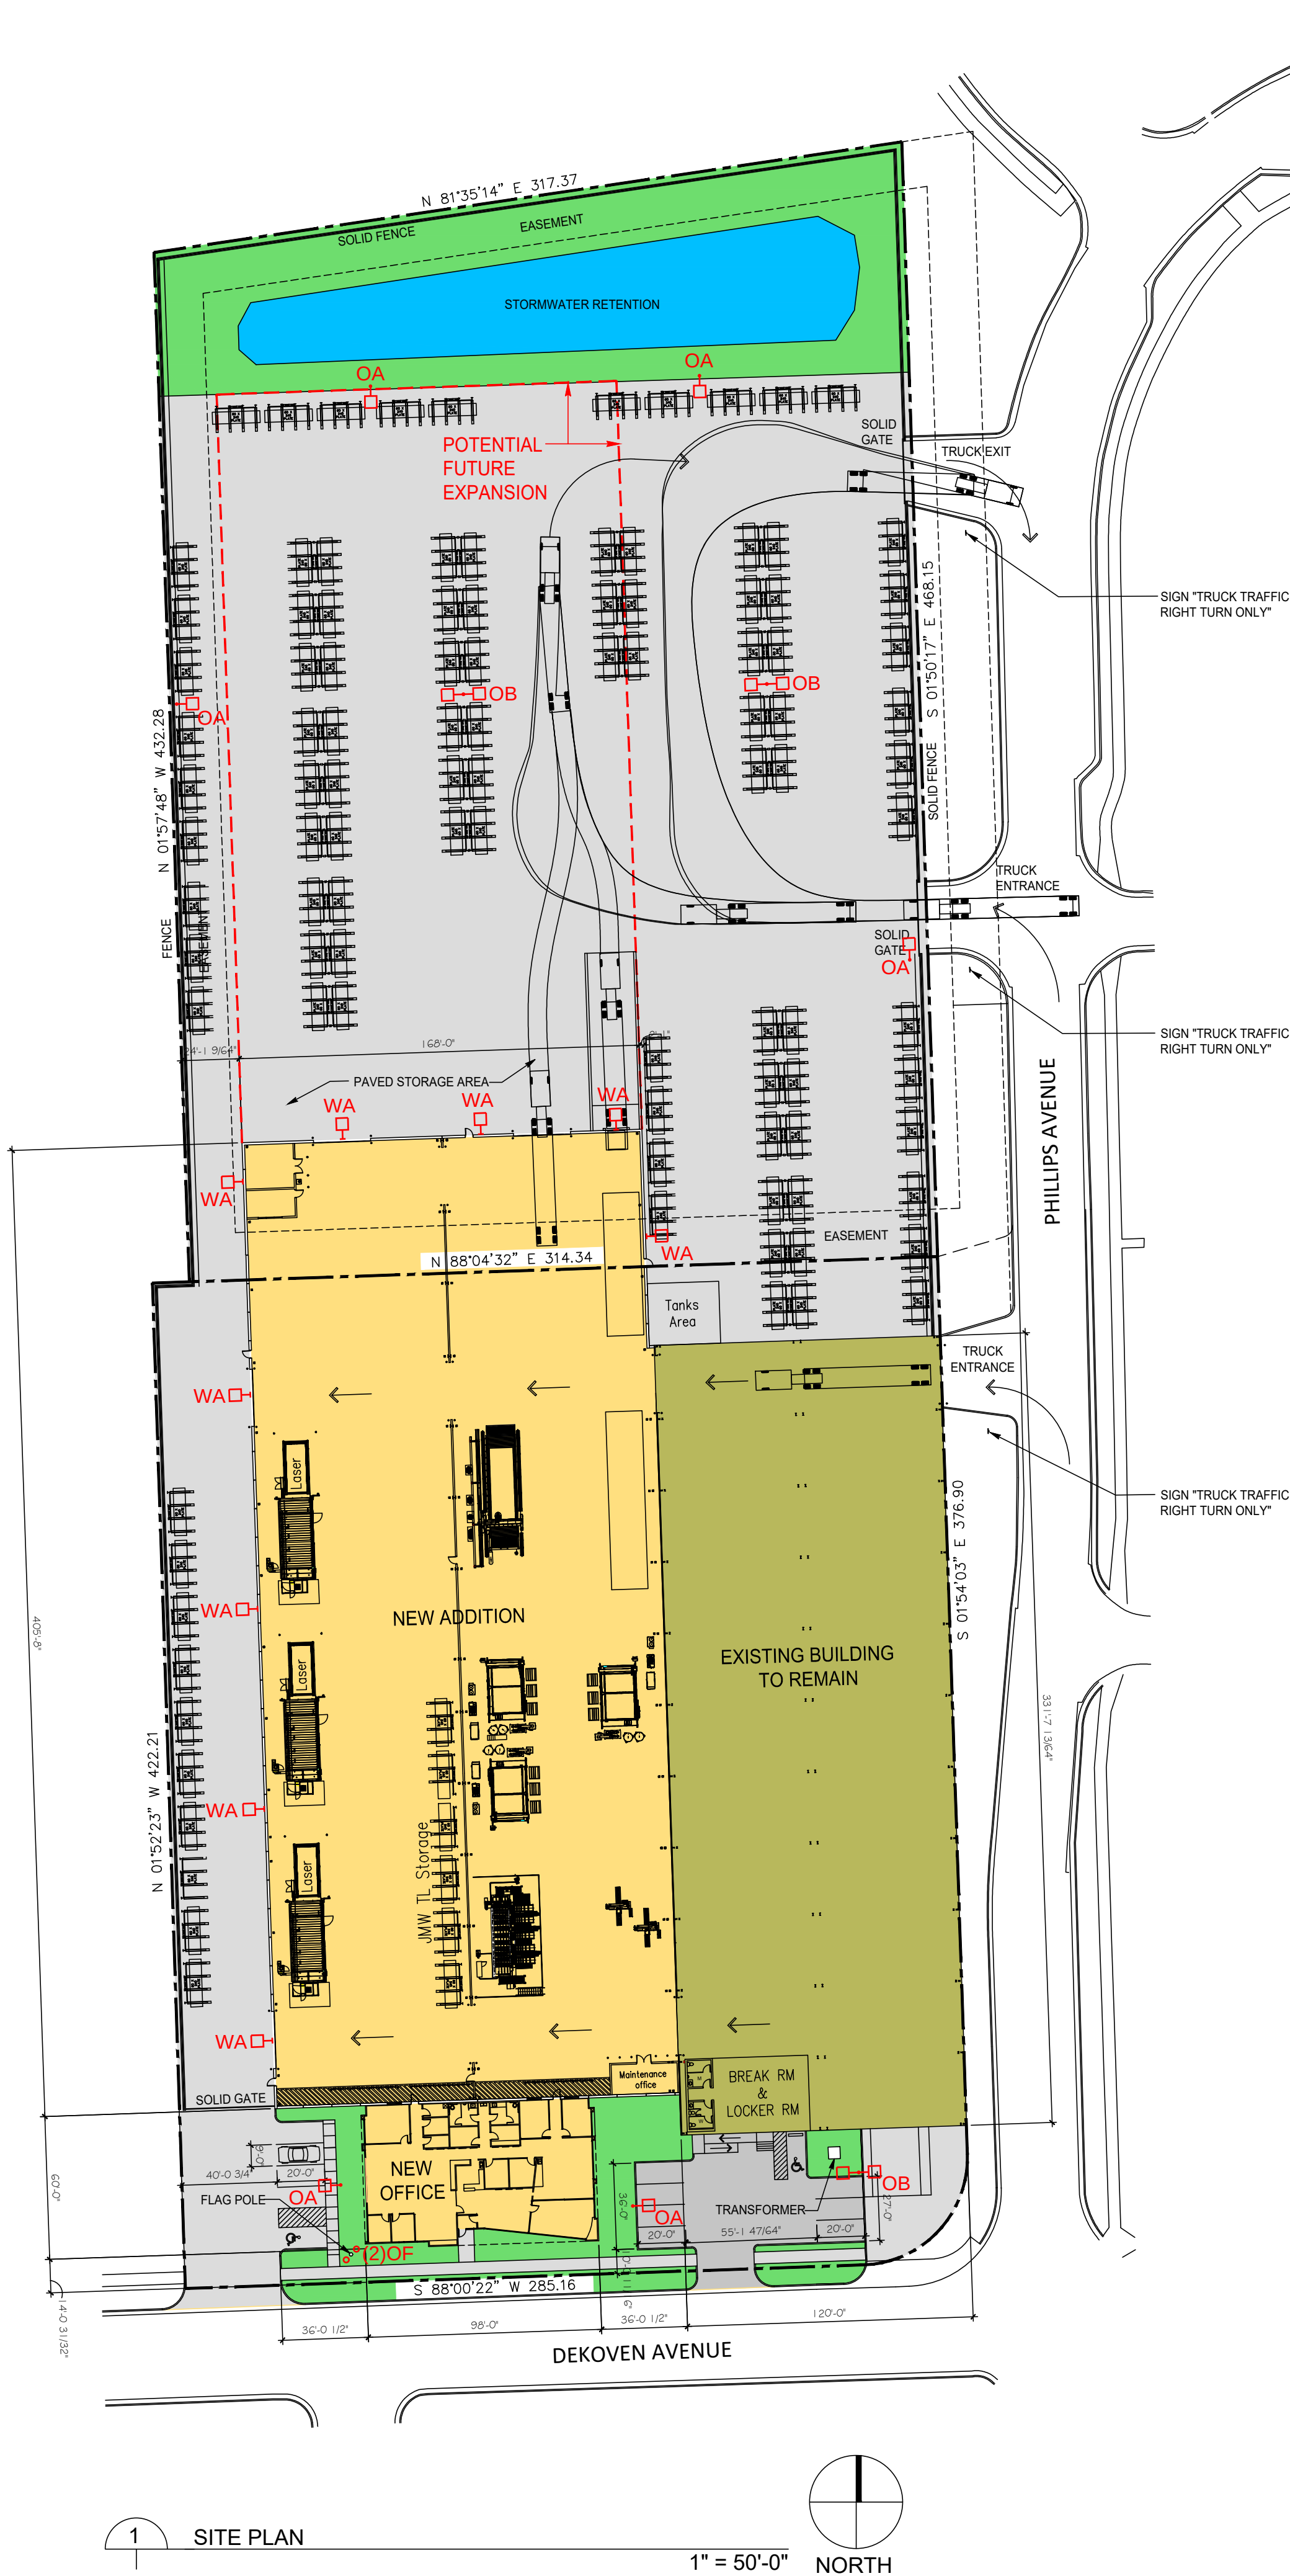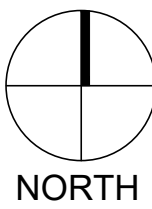

1 SITE PLAN
1" = 50'-0" NORTH

- SYMBOLS:**
- TYPE "OA" SINGLE LUMINAIRE ON 30'H POLE/3'H AFG BASE
 - TYPE "OB" DOUBLE LUMINAIRE ON 30'H POLE/3'H AFG BASE
 - TYPE "OF" FLAGPOLE SPOTLIGHT
 - TYPE "WA" WALL MTD. LUMINAIRE

- GENERAL NOTES:**
- REFER TO ATTACHED LIGHTING FIXTURE CUTSHEETS FOR SPECIFIC FIXTURES BEING PROPOSED. EXACT OUTPUT(S), DISTRIBUTION(S), KELVIN COLOR TEMP., POLE HEIGHT, ETC. TO BE DETERMINED.
 - EGRESS LIGHTING NOT INCLUDED WITH THIS PLAN; RECESSED FIXTURES SHALL BE PROVIDED AT ALL EXIT DOORS WITH CANOPIES AND WALL MOUNTED FIXTURES SHALL BE PROVIDED AT ALL EXITS DOORS WITHOUT CANOPIES. WHERE (1) FIXTURE IS BEING USED, THAT FIXTURE SHALL UTILIZE (2) MODULES/(2) DRIVERS TO COMPLY WITH THE EGRESS CODE.
 - LIGHTING SHALL BE CONTROLLED VIA A TIMECLOCK SYSTEM CONSISTING OF AT LEAST (3) SEPARATELY CONTROLLED ZONES:
 - POLE FIXTURES ALONG DEKOVEN AVE.,
 - BUILDING MOUNTED FIXTURES
 - POLE FIXTURES WITHIN FENCED STORAGE AREA.

PROJECT DESCRIPTION

JACQUET USA IS A SERVICE ORIENTED STAINLESS AND NICKEL ALLOY PROCESSING COMPANY WITH 7 LOCATIONS STRATEGICALLY PLACED ACROSS THE UNITED STATES AND CANADA, TO PROVIDE FAST TURNAROUND AND DELIVERY. CURRENTLY JACQUET MIDWEST OCCUPIES A FACILITY FOR STORAGE AND PROCESSING OF APPROXIMATELY 80,000 SF, IN ORDER TO PROVIDE ITS CUSTOMERS WITH PRODUCTS FROM STATE-OF-THE-ART FACILITIES JACQUET IS PROPOSING TO DEMOLISH APPROXIMATELY 50,000 SF OF LOW BAY SPACE AND CONSTRUCT APPROXIMATELY 74,000 SF OF CRANE SPACE ALONG WITH A FUTURE OFFICE FACILITY. IN ADDITION TO THE FACILITY JACQUET IS PROPOSING OUTDOOR STORAGE FOR RAW MATERIAL IN A SCREENED AND SECURE AREA. PARKING FOR GUESTS AND EMPLOYEES WILL BE OFF OF DEKOVEN AND WILL PROVIDE APPROXIMATELY 13 SPACES.

CONSTRUCTION IS ANTICIPATED TO START LATE FALL OF 2021 WITH COMPLETION WITHIN A YEAR OF THE PRODUCTION FACILITY.

HOURS OF OPERATION:
1ST SHIFT: 6:00 A.M. - 3:30 P.M.
2ND SHIFT: 3:30 P.M. - 12:00 A.M.
5-6 DAYS PER WEEK.

ANTICIPATED DELIVERY SCHEDULE:
6:00 A.M. - 5:00 P.M. M-FRI.

MAINTENANCE PLAN:
BUILDING IS EXPECTED TO MAINTAIN "LIKE NEW" CONDITION THROUGHOUT LIFESPAN OF JACQUET OWNERSHIP. GROUNDS WILL BE KEPT PROPERLY THROUGH LANDSCAPE COMPANY CURRENTLY USED BY JACQUET MIDWEST.

GENERAL USE OF BUILDING AND LOT:
BUILDING WILL BE USED FOR STAINLESS STEEL AND NICKEL ALLOY PROCESSING MAINLY THROUGH WATERJET, PLASMA, AND LASER CUTTING PROCESSES, BUT NOT LIMITED TO JUST THIS. ADDITIONAL AVAILABLE PROPERTY WILL BE USED FOR OUTSIDE MATERIAL STORAGE

SITE INFORMATION

ZONING	I-2 GENERAL INDUSTRIAL
SITE AREA	6.44 ACRES
SITE	280,552 SF
BUILDING SETBACKS	NOT GREATER THAN 25'
FRONT	NONE
SIDE	NONE
REAR	NONE
FLOOR AREA RATIO	MAXIMUM PROVIDED
PROVIDED	4.00
BUILDING	
EXISTING BUILDING FLOOR AREA	80,089 S.F.
EXISTING BUILDING FLOOR AREA AFTER DEMOLITION	39,796 S.F.
PROPOSED BUILDING ADDITION FLOOR AREA	74,109 S.F.
TOTAL BUILDING FLOOR AREA AFTER NEW CONSTRUCTION	113,905 S.F.
PARKING - CLASS NUMBER 23	8
REQUIRED - 12 EMPLOYEES @ 2 SPACES PER 3 EMPLOYEES PROVIDED	13

DRAWING INDEX

A-001	ARCHITECTURAL SITE PLAN
A-201	EXTERIOR ELEVATIONS
A-202	EXTERIOR ELEVATIONS
A-203	RENDERINGS
A-204	RENDERINGS
A-207	RENDERINGS
A-208	RENDERINGS
L-001	LANDSCAPE PLAN
E-001	SITE LIGHTING PLAN



D-Series Size 1 LED Area Luminaire



d#series

Catalog
Number

Notes


Type

TYPE OA/OB

Hit the Tab key or mouse over the page to see all interactive elements.

Specifications

EPA:	1.01 ft ² (0.09 m ²)
Length:	33" (83.8 cm)
Width:	13" (33.0 cm)
Height H1:	7-1/2" (19.0 cm)
Height H2:	3-1/2"
Weight (max):	27 lbs (12.2 kg)

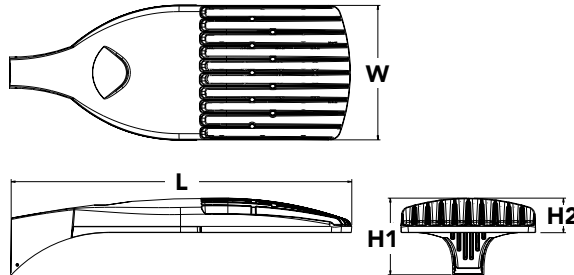

Introduction

The modern styling of the D-Series is striking yet unobtrusive - making a bold, progressive statement even as it blends seamlessly with its environment. The D-Series distills the benefits of the latest in LED technology into a high performance, high efficacy, long-life luminaire.

The outstanding photometric performance results in sites with excellent uniformity, greater pole spacing and lower power density. It is ideal for replacing up to 750W metal halide in pedestrian and area lighting applications with typical energy savings of 65% and expected service life of over 100,000 hours.

Ordering Information

EXAMPLE: DSX1 LED P7 40K T3M MVOLT SPA NLTAIR2 PIRHN DDBXD

DSX1 LED						
Series	LEDs	Color temperature	Distribution	Voltage	Mounting	
DSX1 LED	Forward optics	30K 3000 K	T1S Type I short	T5VS Type V very short ³	MVOLT ⁵	Shipped included
	P1 P4 ¹ P7 ¹	40K 4000 K	(Automotive)	T5S Type V short ³	XVOLT (277V-480V) ^{6,7,8}	SPA Square pole mounting
	P2 P5 ¹ P8	50K 5000 K	T2S Type II short	T5M Type V medium ³	120 ⁹	RPA Round pole mounting ¹⁰
	P3 P6 ¹ P9 ¹		T2M Type II medium	T5W Type V wide ³	208 ⁹	WBA Wall bracket ³
	Rotated optics		T3S Type III short	BLC Backlight control ⁴	240 ⁹	SPUMBA Square pole universal mounting adaptor ¹¹
	P10 ² P12 ²		T3M Type III medium	LCCO Left corner cutoff ⁴	277 ⁹	RPUMBA Round pole universal mounting adaptor ⁹
	P11 ² P13 ^{1,2}		T4M Type IV medium	RCCO Right corner cutoff ⁴	347 ⁹	Shipped separately
			TFTM Forward throw medium		480 ⁹	KMA8 DDBXD U Mast arm mounting bracket adaptor (specify finish) ¹²

Control options			Other options		Finish <i>(required)</i>		
Shipped installed			Shipped installed		Shipped installed		
NLTAIR2	nLight AIR generation 2 enabled ¹³	PIR	High/low, motion/ambient sensor, 8–15’ mounting height, ambient sensor enabled at 5fc ^{20,21}	HS	House-side shield ²³	DDBXD	Dark bronze
PIRHN	Network, high/low motion/ambient sensor ¹⁴	PIRHH	High/low, motion/ambient sensor, 15–30’ mounting height, ambient sensor enabled at 5fc ^{20,21}	SF	Single fuse (120, 277 , 347V) ⁹	DBLXD	Black
PER	NEMA twist-lock receptacle only (controls ordered separate) ¹⁵	PIR1FC3V	High/low, motion/ambient sensor, 8–15’ mounting height, ambient sensor enabled at 1fc ^{20,21}	DF	Double fuse (208, 240, 480V) ⁹	DNAXD	Natural aluminum
PER5	Five-pin receptacle only (controls ordered separate) ^{15,16}	PIRHH1FC3V	Bi-level, motion/ambient sensor, 15–30’ mounting height, ambient sensor enabled at 1fc ^{20,21}	L90	Left rotated optics ²	DWHXD	White
PER7	Seven-pin receptacle only (controls ordered separate) ^{15,16}	FAO	Field adjustable output ^{20,21}	R90	Right rotated optics ²	DDBTXD	Textured dark bronze
DMG	0–10v dimming wires pulled outside fixture (for use with an external control, ordered separately) ¹⁷			HA	50°C ambient operations ¹	DBLBXD	Textured black
DS	Dual switching ^{18,19,20}			Shipped separately		DNATXD	Textured natural aluminum
				BS	Bird spikes ²⁴	DWHGXD	Textured white
				EGS	External glare shield		



COMMERCIAL OUTDOOR

One Lithonia Way • Conyers, Georgia 30012 • Phone: 1-800-705-SERV (7378) • www.lithonia.com
 © 2011-2020 Acuity Brands Lighting, Inc. All rights reserved.

DSX1-LED

Rev. 11/16/20

Page 1 of 8



by Signify

Site & Area

PureForm

P26 medium area light



Gardco PureForm LED area medium P26 features a sleek, low profile design and optimal performance. PureForm area medium is designed to achieve maximum pole spacing, with lumen output up to 28,900 lumens. Multiple distribution and shielding options are available to achieve maximum control. A full range of control options provides additional energy savings.

Project:	
Location:	
Cat.No:	
Type:	TYPE OA/OB
Lumens:	Qty:
Notes:	

Ordering guide

example: **P26-64L-800-NW-G2-AR-3-120-HIS-MGY**

Prefix	Number of LEDs	Drive Current	LED Color – Generation	Mounting	Distribution	Voltage	
P26							
P26 PureForm area medium, 26"	48L 48 LEDs (3 modules)	400 400mA	WW-G2 Warm White 3000K, 70 CRI Generation 2	AR Arm Mount (standard) ² The following mounting kits must be ordered separately (See accessories) SF Slip Fitter Mount ³ (fits to 2 3/8" O.D. tenon) WS Wall mount with surface conduit rear entry permitted RAM Retrofit arm mount kit ²	Type 2 2 Type 2 2-90 Rotated left 90° 2-270 Rotated right 270°	120 120V	
		500 500mA	NW-G2 Neutral White 4000K, 70 CRI Generation 2		Type 5 5 Type 5 5W Type 5W	208 208V	
		600 600mA			AFR Auto Front Row	240 240V	
	64L 64 LEDs (4 modules)	600 600mA	CW-G2 Cool White 5000K, 70 CRI Generation 2		AFR-90 Auto Front Row, rotated left 90°	277 277V	
		700 700mA			AFR-270 Auto Front Row, rotated right 270°	347 347V	
		800 800mA			BLC Back Light Control	480 480V	
	80L 80 LEDs (5 modules)	700 700mA	WY-G2 Warm Yellow 2700K, 80 CRI Generation 2 ¹		BLC-90 Back Light Control rotated at 90°	UNV 120-277V (50/60Hz)	
		800 800mA			BLC-270 Back Light Control rotated at 270°	HVU 347-480V (50/60Hz)	
		900 900mA					
			BW-G2 Balanced White 3500K 80CRI Generation 2 ¹				
			AM-G2 Direct Amber (590nm) Generation 2 ^{1,15}				
	Options						
Dimming controls		Motion sensing lens	Photo-sensing	Electrical	Luminaire	Finish	
DD 0-10V External dimming (by others) ⁴ DCC Dual Circuit Control ^{4,5,6} FAWS Field Adjustable Wattage Selector ^{4,5} SW Interface module for SiteWise ^{4,6,7} LLC Integral wireless module ^{4,6,8,19} BL Bi-level functionality ^{4,19} DynaDimmer: Automatic Profile Dimming CS50 Security 50% Dimming, 7 hours ^{4,8} CM50 Median 50% Dimming, 8 hours ^{4,8} CS30 Security 30% Dimming, 7 hours ^{4,8} CM30 Median 30% Dimming, 8 hours ^{4,8}		IMR13 Integral with #3 lens ¹⁶ IMR17 Integral with #7 lens ¹⁷	PCB Photocontrol Button ^{8,9} TLRD5 Twist Lock Receptacle 5 Pin ¹⁰ TLRD7 Twist Lock Receptacle 7 Pin ¹⁰ TLRPC Twist Lock Receptacle w/Photocell ^{9,11}	Fusing F1 Single (120, 277, 347VAC) ⁹ F2 Double (208, 240, 480VAC) ⁹ F3 Canadian Double Pull (208, 240, 480VAC) ^{9,12} Pole Mount Fusing FP1 Single (120, 277, 347VAC) ⁹ FP2 Double (208, 240, 480VAC) ⁹ FP3 Canadian Double Pull (208, 240, 480VAC) ⁹ Surge Protection (10kA standard) SP2 Increased 20kA	Square Pole Adapter included as standard TB Terminal Block ¹² RPA Round Pole Adapter (fits to 3"- 3.9" O.D. pole) ¹³ HIS Internal Housing Side Shield ¹⁴	Textured BK Black WH White BZ Bronze DGY Dark Gray MGY Medium Gray Customer specified RAL Specify optional color or RAL (ex: RAL7024) CC Custom color (Must supply color chip for required factory quote)	

- | | | |
|--|--|--|
| 1. Extended lead times apply. Contact factory for details. | 9. Must specify input voltage. | 14. HIS not available with Type 5, 5W, and BLC optics. |
| 2. Mounts to a 4-5" round pole with adapter included for square poles. | 10. Dimming will not be connected to NEMA receptacle if ordering with other control options. | 15. Limited to max. 600mA configurations. |
| 3. Limited to a maximum of 45 degrees aiming above horizontal. | 11. Not available in 480V. Order photocell separately with TLRD5/7. | 16. Not available with DD, DCC, and FAWS dimming control options. |
| 4. Not available with other dimming control options. | 12. Not available with DCC. | 17. Not available with DD, DCC, FAWS and LLC dimming control options. |
| 5. Not available with motion sensor. | 13. Not available with SF and WS. RPAs provided with black finish standard. | 18. Not available with DD, DCC, FAWS, LLC, and BL dimming control options (SW or DynaDimmer required). |
| 6. Not available with photocontrol. | | 19. Must specify a motion sensor lens. |
| 7. Available only in 120 or 277V. | | |
| 8. Not available in 347 or 480V. | | |




P26 PureForm LED medium

Area light

Dimensions


Standard Arm (AR)

Weight: 27 Lbs (12.4 Kg) EPA: 0.26ft² (.024m²)

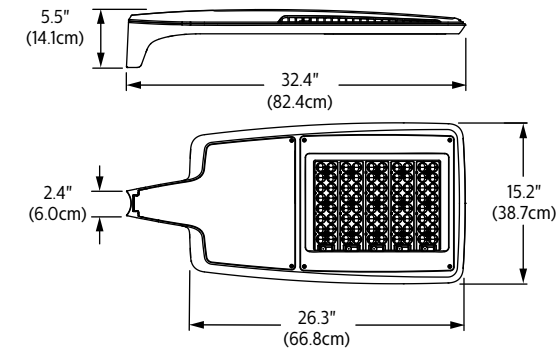


Wall (WS)

Weight: 30 Lbs. (13.7 Kg)EPA: 0.30ft² (.028m²)

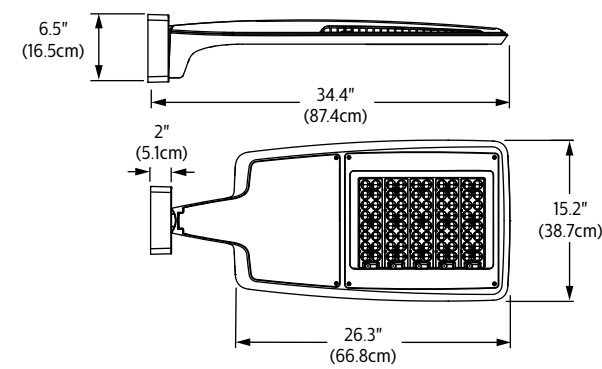


Retrofit Arm (RAM)

Weight: 28 Lbs (12.7 Kg) EPA: 0.28ft² (.026m²)

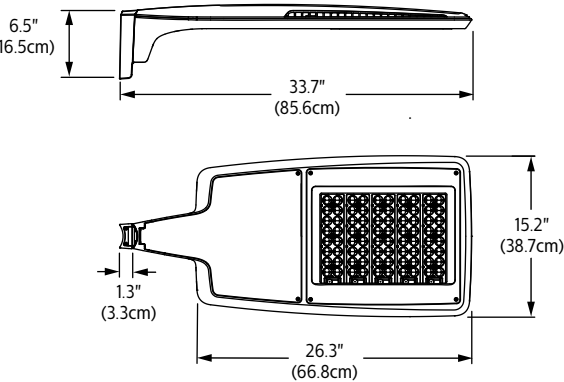


Slip fitter (SF)



Weight: 32 Lbs (14.6 Kg) EPA: 0.38ft² (.035m²)

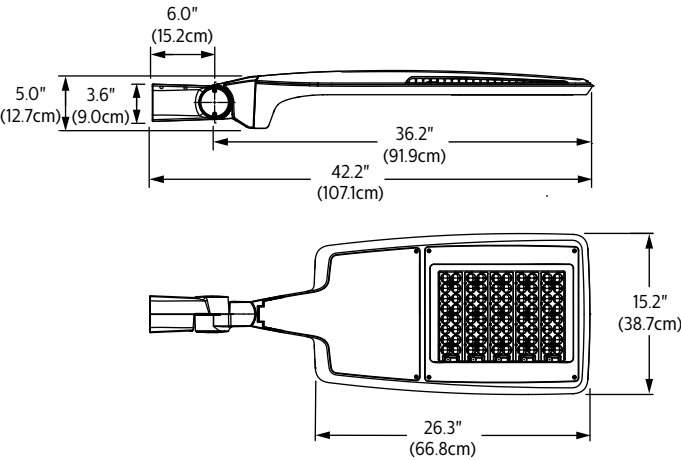


4 module configuration

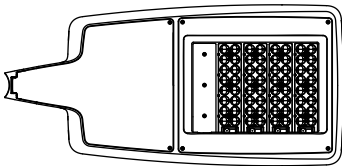


3 module configuration

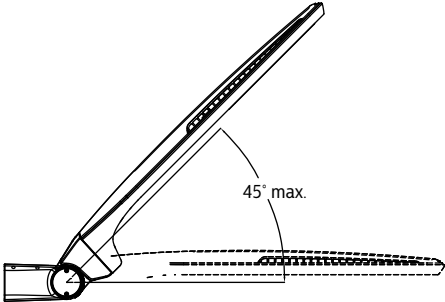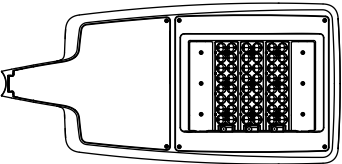

Standard Arm (AR) drill pattern

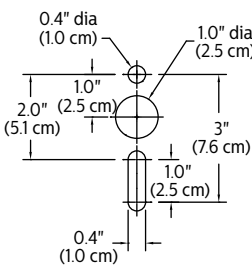

Retrofit arm (RAM) drill pattern

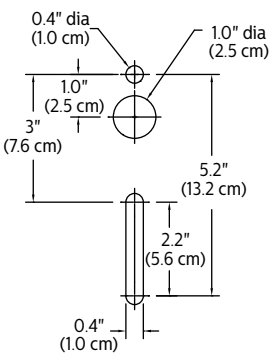

DESCRIPTION

The Galleonaire LED luminaire features advanced thermally conductive polymer heatsinks and open frame endcaps for a sleek aesthetic with significant weight reduction. Patented, high-efficiency AccuLED Optics™ system provides uniform and energy conscious illumination to walkways, parking lots, roadways, building areas and security lighting applications. IP66 rated and UL/cUL Listed for wet locations.

Catalog #		Type
Project		
Comments	TYPE OA/OB	Date
Prepared by		

SPECIFICATION FEATURES

Construction

Extruded aluminum driver enclosure thermally isolated from Light Squares for optimal thermal performance. Open frame die-cast aluminum end caps provide structural support for the housing and heatsinks. Thermally conductive polymer heatsinks offer significant weight reduction while fully maintaining thermal management of the Light Squares. 3G vibration tested and rated. Optional tool-less hardware available for ease of entry into electrical chamber. Housing is IP66 rated.

Optics

Patented, high-efficiency injection-molded AccuLED Optics technology. Optics are precisely designed to shape the distribution, maximizing efficiency and application spacing. AccuLED Optics create consistent distributions with the scalability to meet customized application requirements. Offered standard in 4000K (+/- 275K) CCT 70 CRI. Optional 2700K, 3000K, 5000K and 6000K CCT.

Electrical

LED drivers are mounted to removable tray assembly for ease of maintenance. 120-277V 50/60Hz, 347V 60Hz or 480V 60Hz operation. 480V is compatible for use with 480V Wye systems only. Standard with 0-10V dimming. Shipped standard with Cooper Lighting Solutions proprietary circuit module designed to withstand 10kV of transient line surge. The Galleonaire LED luminaire is suitable for operation in -40°C to 40°C ambient environments. Light Squares are IP66 rated. Greater than 90% lumen maintenance expected at 60,000 hours. Available in standard 1A drive current and optional 600mA and 800mA drive currents (nominal).

Mounting

STANDARD ARM MOUNT: Extruded aluminum arm includes internal bolt guides allowing for easy positioning of fixture during mounting. When mounting two or more luminaires at 90° and 120° apart, the EA extended arm may be required. Refer to the arm mounting requirement table. Round pole adapter included. For wall mounting, specify wall

mount bracket option. **QUICK MOUNT ARM:** Adapter is bolted directly to the pole. Quick mount arm slide into place on the adapter and is secured via two screws, facilitating quick and easy installation. The versatile, patent pending, quick mount arm accommodates multiple drill patterns ranging from 1-1/2" to 4-7/8". Removal of the door on the quick mount arm enables wiring of the fixture without having to access the driver compartment. A knock-out enables round pole mounting.

Finish

Housing finished in super durable TGIC polyester powder coat paint, 2.5 mil nominal thickness for superior protection against fade and wear. Heat sink is dark gray, non-paintable. Standard housing colors include black, bronze, grey, white, dark platinum and graphite metallic. RAL and custom color matches available.

Warranty

Five-year warranty.



GLNA GALLEONAIRE


1-10 Light Squares
Solid State LED

AREA/SITE LUMINAIRE



WaveLinx

DIMENSIONS

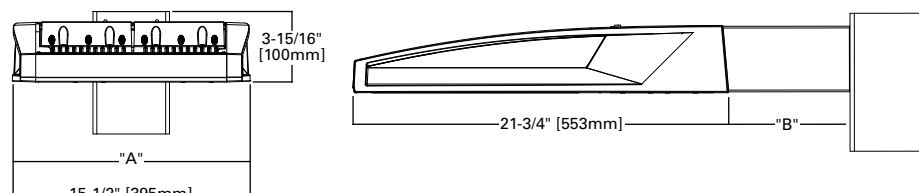


DIMENSION DATA

Number of Light Squares	"A" Width	"B" Standard Arm Length	"B" Optional Arm Length ¹	Weight with Arm (lbs.)	EPA with Arm ² (Sq. Ft.)
1-4	15-1/2" (394mm)	7" (178mm)	10" (254mm)	28 (12.7 kgs)	0.72
5-6	21-5/8" (549mm)	7" (178mm)	10" (254mm)	38 (16.3 kgs)	0.77
7-8	27-5/8" (702mm)	7" (178mm)	13" (330mm)	43 (19.5 kgs)	0.95
9-10	33-3/4" (857mm)	7" (178mm)	16" (406mm)	49 (22.2 kgs)	1.13

NOTES: 1. Optional arm length to be used when mounting two fixtures at 90° on a single pole. 2. EPA calculated with optional arm length.

DRILLING PATTERN

TYPE "N"

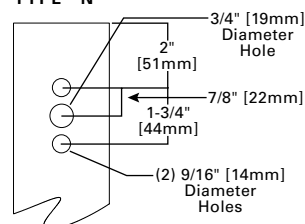

CERTIFICATION DATA


3G Vibration Rated
IP66 Rated
ISO 9001
LM79 / LM80 Compliant
UL/cUL Wet Location Listed

ENERGY DATA

Electronic LED Driver
>0.9 Power Factor
<20% Total Harmonic Distortion
120V-277V 50/60Hz
347V, 480V 60Hz
-40°C Min. Temperature
40°C Max. Temperature


ARM MOUNTING REQUIREMENTS

Configuration	90° Apart	120° Apart
GLNA-AF-01	7" Arm (Standard)	7" Arm (Standard)
GLNA-AF-02	7" Arm (Standard)	7" Arm (Standard)
GLNA-AF-03	7" Arm (Standard)	7" Arm (Standard)
GLNA-AF-04	7" Arm (Standard)	7" Arm (Standard)
GLNA-AF-05	10" Extended Arm (Required)	7" Arm (Standard)
GLNA-AF-06	10" Extended Arm (Required)	7" Arm (Standard)
GLNA-AF-07	13" Extended Arm (Required)	13" Extended Arm (Required)
GLNA-AF-08	13" Extended Arm (Required)	13" Extended Arm (Required)
GLNA-AF-09	16" Extended Arm (Required)	16" Extended Arm (Required)
GLNA-AF-10	16" Extended Arm (Required)	16" Extended Arm (Required)

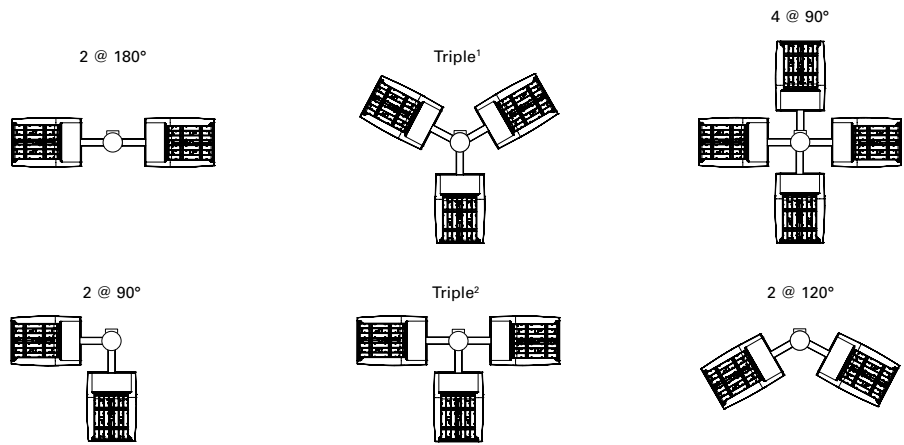


NOTES: 1 Round poles are 3 @ 120°. Square poles are 3 @ 90°. 2 Round poles are 3 @ 90°.


STANDARD WALL MOUNT

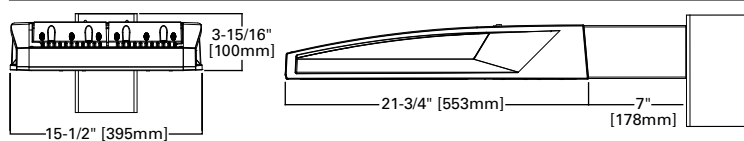


MAST ARM MOUNT

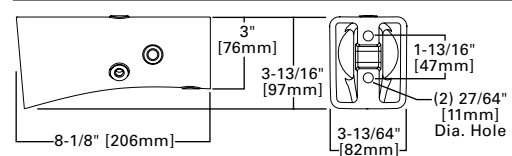


QUICK MOUNT ARM (INCLUDES FIXTURE ADAPTER)

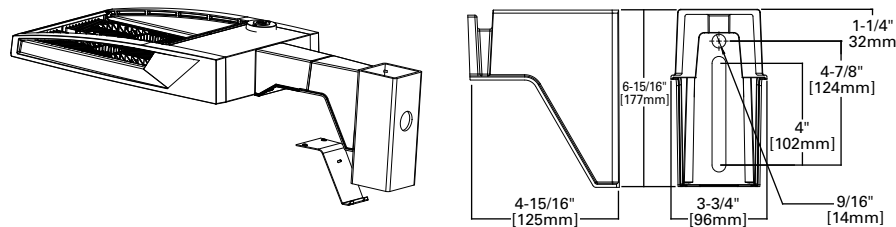

QM Quick Mount Arm (Standard)

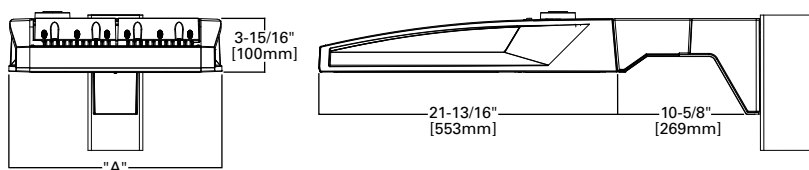

QMEA Quick Mount Arm (Extended)

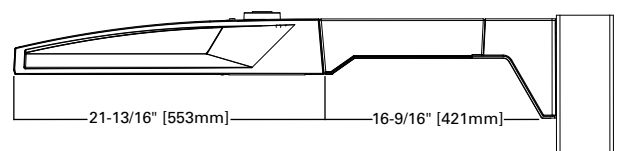

QUICK MOUNT ARM DATA

Number of Light Squares ^{1,2}	"A" Width	Weight with QM Arm (lbs.)	Weight with QMEA Arm (lbs.)	EPA with Arm ² (Sq. Ft.)
1-4	15-1/2" (394mm)	30 (13.6 kgs)	33 (15 kgs)	0.96
5-6 ³	21-5/8" (549mm)	38 (17.2 kgs)	41 (18.6 kgs)	
7-8 ⁴	27-5/8" (702mm)	45 (20.4 kgs)	--	

NOTES: 1. Optional arm length to be used when mounting two fixtures at 90° on a single pole. 2. EPA calculated with standard arm length. 3. QMEA arm to be used when mounting two fixtures at 90° on a single pole. 4. QM options not available for 90° or 120° configuration on a single pole.




d^{series}

D-Series Size 2 LED Wall Luminaire



Back Box (BBW)

Width:	5-1/2" (14.0 cm)	BBW Weight:	1 lbs (0.5 kg)
Depth:	1-1/2" (3.8 cm)		
Height:	4" (10.2 cm)		

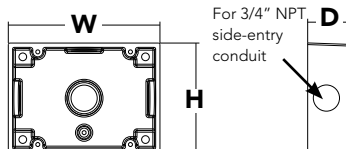

Specifications Luminaire

Width:	18-1/2" (47.0 cm)	Weight:	21 lbs (9.5 kg)
Depth:	10" (25.4 cm)		
Height:	7-5/8" (19.4 cm)		



Catalog
Number

Notes

Type

TYPE WA

Hit the Tab key or mouse over the page to see all interactive elements.

A+ Capable Luminaire

This item is an A+ capable luminaire, which has been designed and tested to provide consistent color appearance and system-level interoperability.

- All configurations of this luminaire meet the Acuity Brands' specification for chromatic consistency
- This luminaire is A+ Certified when ordered with DTL[®] controls marked by a **shaded background**. DTL DLL equipped luminaires meet the A+ specification for luminaire to photocontrol interoperability¹
- This luminaire is part of an A+ Certified solution for ROAM[®] or XPoint[™] Wireless control networks, providing out-of-the-box control compatibility with simple commissioning, when ordered with drivers and control options marked by a **shaded background**¹

To learn more about A+, visit www.acuitybrands.com/aplus.

1. See ordering tree for details.
2. A+ Certified Solutions for ROAM require the order of one ROAM node per luminaire. Sold Separately: [Link to Roam](#); [Link to DTL DLL](#)

A+ Capable options indicated by this color background.

Ordering Information

EXAMPLE: DSXW2 LED 30C 700 40K T3M MVOLT DDBTXD

DSXW2 LED							
Series	LEDs	Drive Current	Color temperature	Distribution	Voltage	Mounting	Control Options
DSXW2 LED	20C 20 LEDs (two engines)	350 350 mA 530 530 mA 700 700 mA	30K 3000 K 40K 4000 K 50K 5000 K	T2S Type II Short T2M Type II Medium T3S Type III Short T3M Type III Medium T4M Type IV Medium TFTM Forward Throw Medium	MVOLT ³ 120 ⁴ 208 ⁴ 240 ⁴ 277 ⁴ 347 ^{4,5} 480 ^{4,5}	Shipped included (blank) Surface mounting bracket Shipped separately⁶ BBW Surface-mounted back box (for conduit entry)	Shipped installed PE Photoelectric cell, button type ⁷ PER NEMA twist-lock receptacle only (control ordered separately) ⁸ PER5 Five-wire receptacle only (control ordered separately) ^{8,9} PER7 Seven-wire receptacle only (control ordered separately) ^{8,9}
	30C 30 LEDs (three engines)	1000 1000 mA ¹ (1 A)	AMBPC Amber phosphor converted ²				DMG 0-10v dimming wires pulled outside fixture (for use with an external control, ordered separately) PIR 180° motion/ambient light sensor, <15' mtg ht ^{10,11} PIRH 180° motion/ambient light sensor, 15-30' mtg ht ^{10,11} PIR1FC3V Motion/ambient sensor, 8-15' mounting height, ambient sensor enabled at 1fc ^{11,12} PIRH1FC3V Motion/ambient sensor, 15-30' mounting height, ambient sensor enabled at 1fc ^{11,12}

Other Options		Finish (required)			
Shipped installed		Shipped separately¹³			
SF	Single fuse (120, 277, 347V) ³	BSW	Bird-deterrent spikes	DDBXD	Dark bronze
DF	Double fuse (208, 240, 480V) ³	VG	Vandal guard	DBLXD	Black
HS	House-side shield ⁴			DNAXD	Natural aluminum
SPD	Separate surge protection ¹³			DWHXD	White
				DSSXD	Sandstone
				DDBTXD	Textured dark bronze
				DBLBXD	Textured black
				DNATXD	Textured natural aluminum
				DWHGXD	Textured white
				DSSTXD	Textured sandstone



One Lithonia Way • Conyers, Georgia 30012 • Phone: 1-800-705-SERV (7378) • www.lithonia.com
© 2012-2021 Acuity Brands Lighting, Inc. All rights reserved.

DSXW2-LED
Rev. 04/19/21
Page 1 of 4

COMMERCIAL OUTDOOR



Gardco PureForm LED wall scone PWS with precision optics offers a sleek, low profile design that will complement a range of architectural styles. PureForm wall scone provides up to 21,800 lumens to accommodate multiple mounting heights, and is available with Type 2, 3, 4, as well as our back light control optics. A full range of control options is available for additional energy savings. Optional emergency battery backup option is available for path-of-egress and is integral to the luminaire.

Project: _____
 Location: _____
 Cat.No: _____
 Type: **TYPE WA**
 Lamps: _____ Qty: _____
 Notes: _____

Ordering guide

example: **PWS-48L-500-NW-G2-2-UNV-DGY**

Prefix	Number of LEDs	Drive Current	LED Color - Generation	Distribution	Emergency	Voltage	Options				Finish				
							Dimming controls	Motion-sensing lens	Photo-sensing	Electrical & Shield					
PWS															
PWS PureForm wall scone	48L 48 LEDs	300 300mA ¹	WW-G2 Warm White 3000K, 70 CRI Generation 2	2 Type 2	EBPC Emergency Battery Pack Cold Weather ^{1,3,10} Leave blank to omit an emergency option	UNV 120-277V	DD 0-10V External dimming (controls by others) ⁴	IMRI2 ¹⁵ Integral with #2 lens IMRI3 ¹⁵ Integral with #3 lens	PCB Photocontrol Button ^{7,8,12}	Fusing		BK Black WH White BZ Bronze DGY Dark Gray MGY Medium Gray Customer specified			
		400 400mA	NW-G2 Neutral White 4000K, 70 CRI Generation 2	3 Type 3		HVU 347-480V	DCC Dual Circuit Control ^{4,5,6,9}						F1 Single (120, 277, 347VAC) ⁸	RAL Specify optional color or RAL (ex: RAL7024)	
		500 500mA		4 Type 4		120 120V	FAWS Field Adjustable Wattage Selector ^{4,5}						F2 Double (208, 240, 480VAC) ⁸		
		600 600mA		BLC Back light control		208 208V	SW Interface Module for SiteWise ^{3,4,6}						F3 Canadian Double Pull (208, 240, 480VAC) ⁸		
		700 700mA	CW-G2 Cool White 5000K, 70 CRI Generation 2			240 240V	LCC Integral wireless module ^{4,6,7,11,14}						Surge Protection (10kA is standard) SP2 Increased 20kA		CC Custom color (Must supply color chip for required factory quote)
	64L 64 LEDs	600 600mA	WY-G2 Warm Yellow 2700K, 80 CRI Generation 2 ²			277 277V	DynaDimmer: Automatic Profile Dimming ^{4,7} CS50 Security 50% Dimming, 7 hours CM50 Median 50% Dimming, 8 hours CS30 Security 30% Dimming, 7 hours CM30 Median 30% Dimming, 8 hours								
		700 700mA				347 347V									
		800 800mA	BW-G2 Balanced White 3500K, 80CRI Generation 2 ²			480 480V									
		900 900mA													
			AM-G2 Direct Amber (590nm) Generation 2 ^{2,13}												

- Only 300mA can be used with battery backup (EBPC) configuration.
- Extended lead times apply. Contact factory for details.
- Available only in 120 or 277V.
- Not available with other dimming control options.
- Not available with motion sensor.

- Not available with photocontrol.
- Not available in 347 or 480V.
- Must specify input voltage.
- Available with two modules per circuit (64L) at 600mA.
- Not available with DCC, SW, and CS/CM.
- Not available in 800 or 900mA.

- Not available with 64L.
- Must specify a motion sensor lens.
- Limited to max. 600mA configurations
- Not available with DD, DCC, and FAWS dimming control options.

PWS PureForm LED wall sconce

wall mount

Luminaire Accessories (order separately)

Mounting Accessories

Wall Mount

PWS-WS-G2	Wall Mounted Box for Surface Conduit Painted Black
-----------	--

System accessories

Wireless system remote mount module



LLCR2-(F) #2 lens - specify finish in place of (F)
LLCR3-(F) #3 lens - specify finish in place of (F)

Central Remote Motion Response (used connected to SiteWise main panel)

MS2-A-FVR-3
MS2-A-FVR-7



Wireless system remote controller accessory

 Wireless system offers a remote radio/sensor module that allows connection to a Limelight system (sold by others). Remote module can be mounted to wall or pole with j-box supplied. May be specified by choosing one of two different lenses to accommodate a variety of mounting heights/sensor detection ranges. Must specify option DD on luminaires that are planned to be used with remote mount controllers.


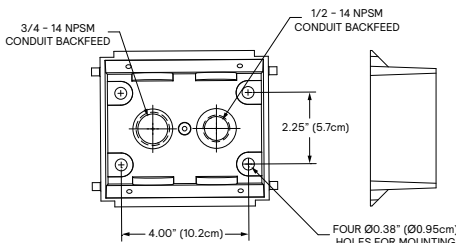


Dimensions



Standard Luminaire

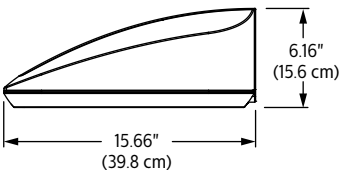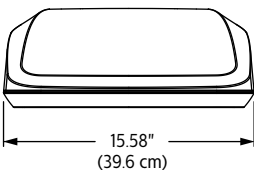


Motion Response and Wireless System

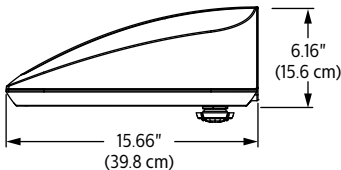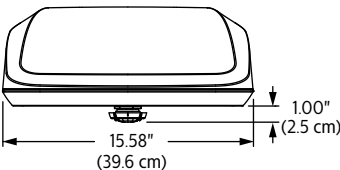

4 modules

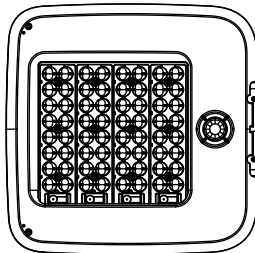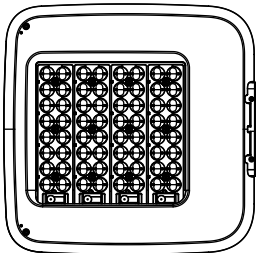

3 modules

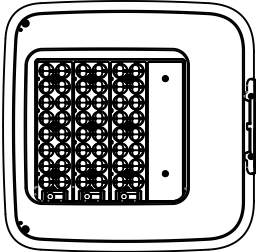

Luminaire Weights

PureForm LED wall sconces PWS	Weight
Luminaire	24 lbs
Luminaire - EBPC (EM battery pack)	27 lbs

Project		Catalog #		Type	TYPE WA
Prepared by		Notes		Date	



McGraw-Edison

GWC Galleon Wall

Wall Mount Luminaire

Typical Applications

Exterior Wall • Walkway


Interactive Menu

- Ordering Information [page 2](#)
- Product Specifications [page 2](#)
- Optical Configurations [page 3](#)
- Energy and Performance Data [page 4](#)
- Control Options [page 6](#)

Quick Facts

- Choice of thirteen high-efficiency, patented AccuLED Optics™
- Downward and inverted wall mounting configurations
- Eight lumen packages from 3,215 up to 17,056
- Efficacies up to 154 lumens per watt

Dimensional Details

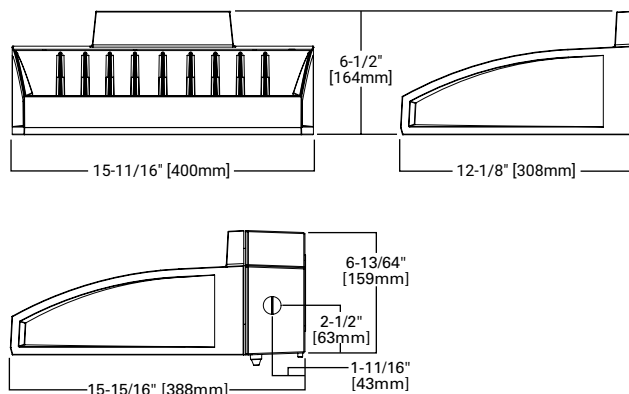

Product Certifications



Connected Systems

- WaveLinx
- Enlighted

